

INDIAN INSTITUTE OF TECHNOLOGY KANPUR
INSTITUTE WORKS DEPARTMENT
CENTRAL OFFICE

CORRIGENDUM

Notice Inviting Tender No. 47/Composite/D1/2025-26

Name of Work: **Construction of Cafeteria at Visitor Hostel - 1 , IIT KANPUR**


The tender drawings for the **Construction of Cafeteria at Visitor Hostel - 1 , IIT KANPUR** are hereby provided for the information of the bidders.

The other terms and conditions of the NIT shall remain the same.


No. IWD/co/2025-26/238

dated 31.10.25

1/10/25
31/10/25


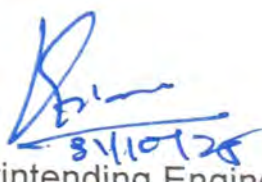

Superintending Engineer

 do not scale this drawing



29.10.25	mail	TO IWD
date	no.	issue

job no.	560/ IIT/ VHCAFE	drg. no. 100
date	OCT 2025	
dealt	AMOL	
scale	1:500 / 150	

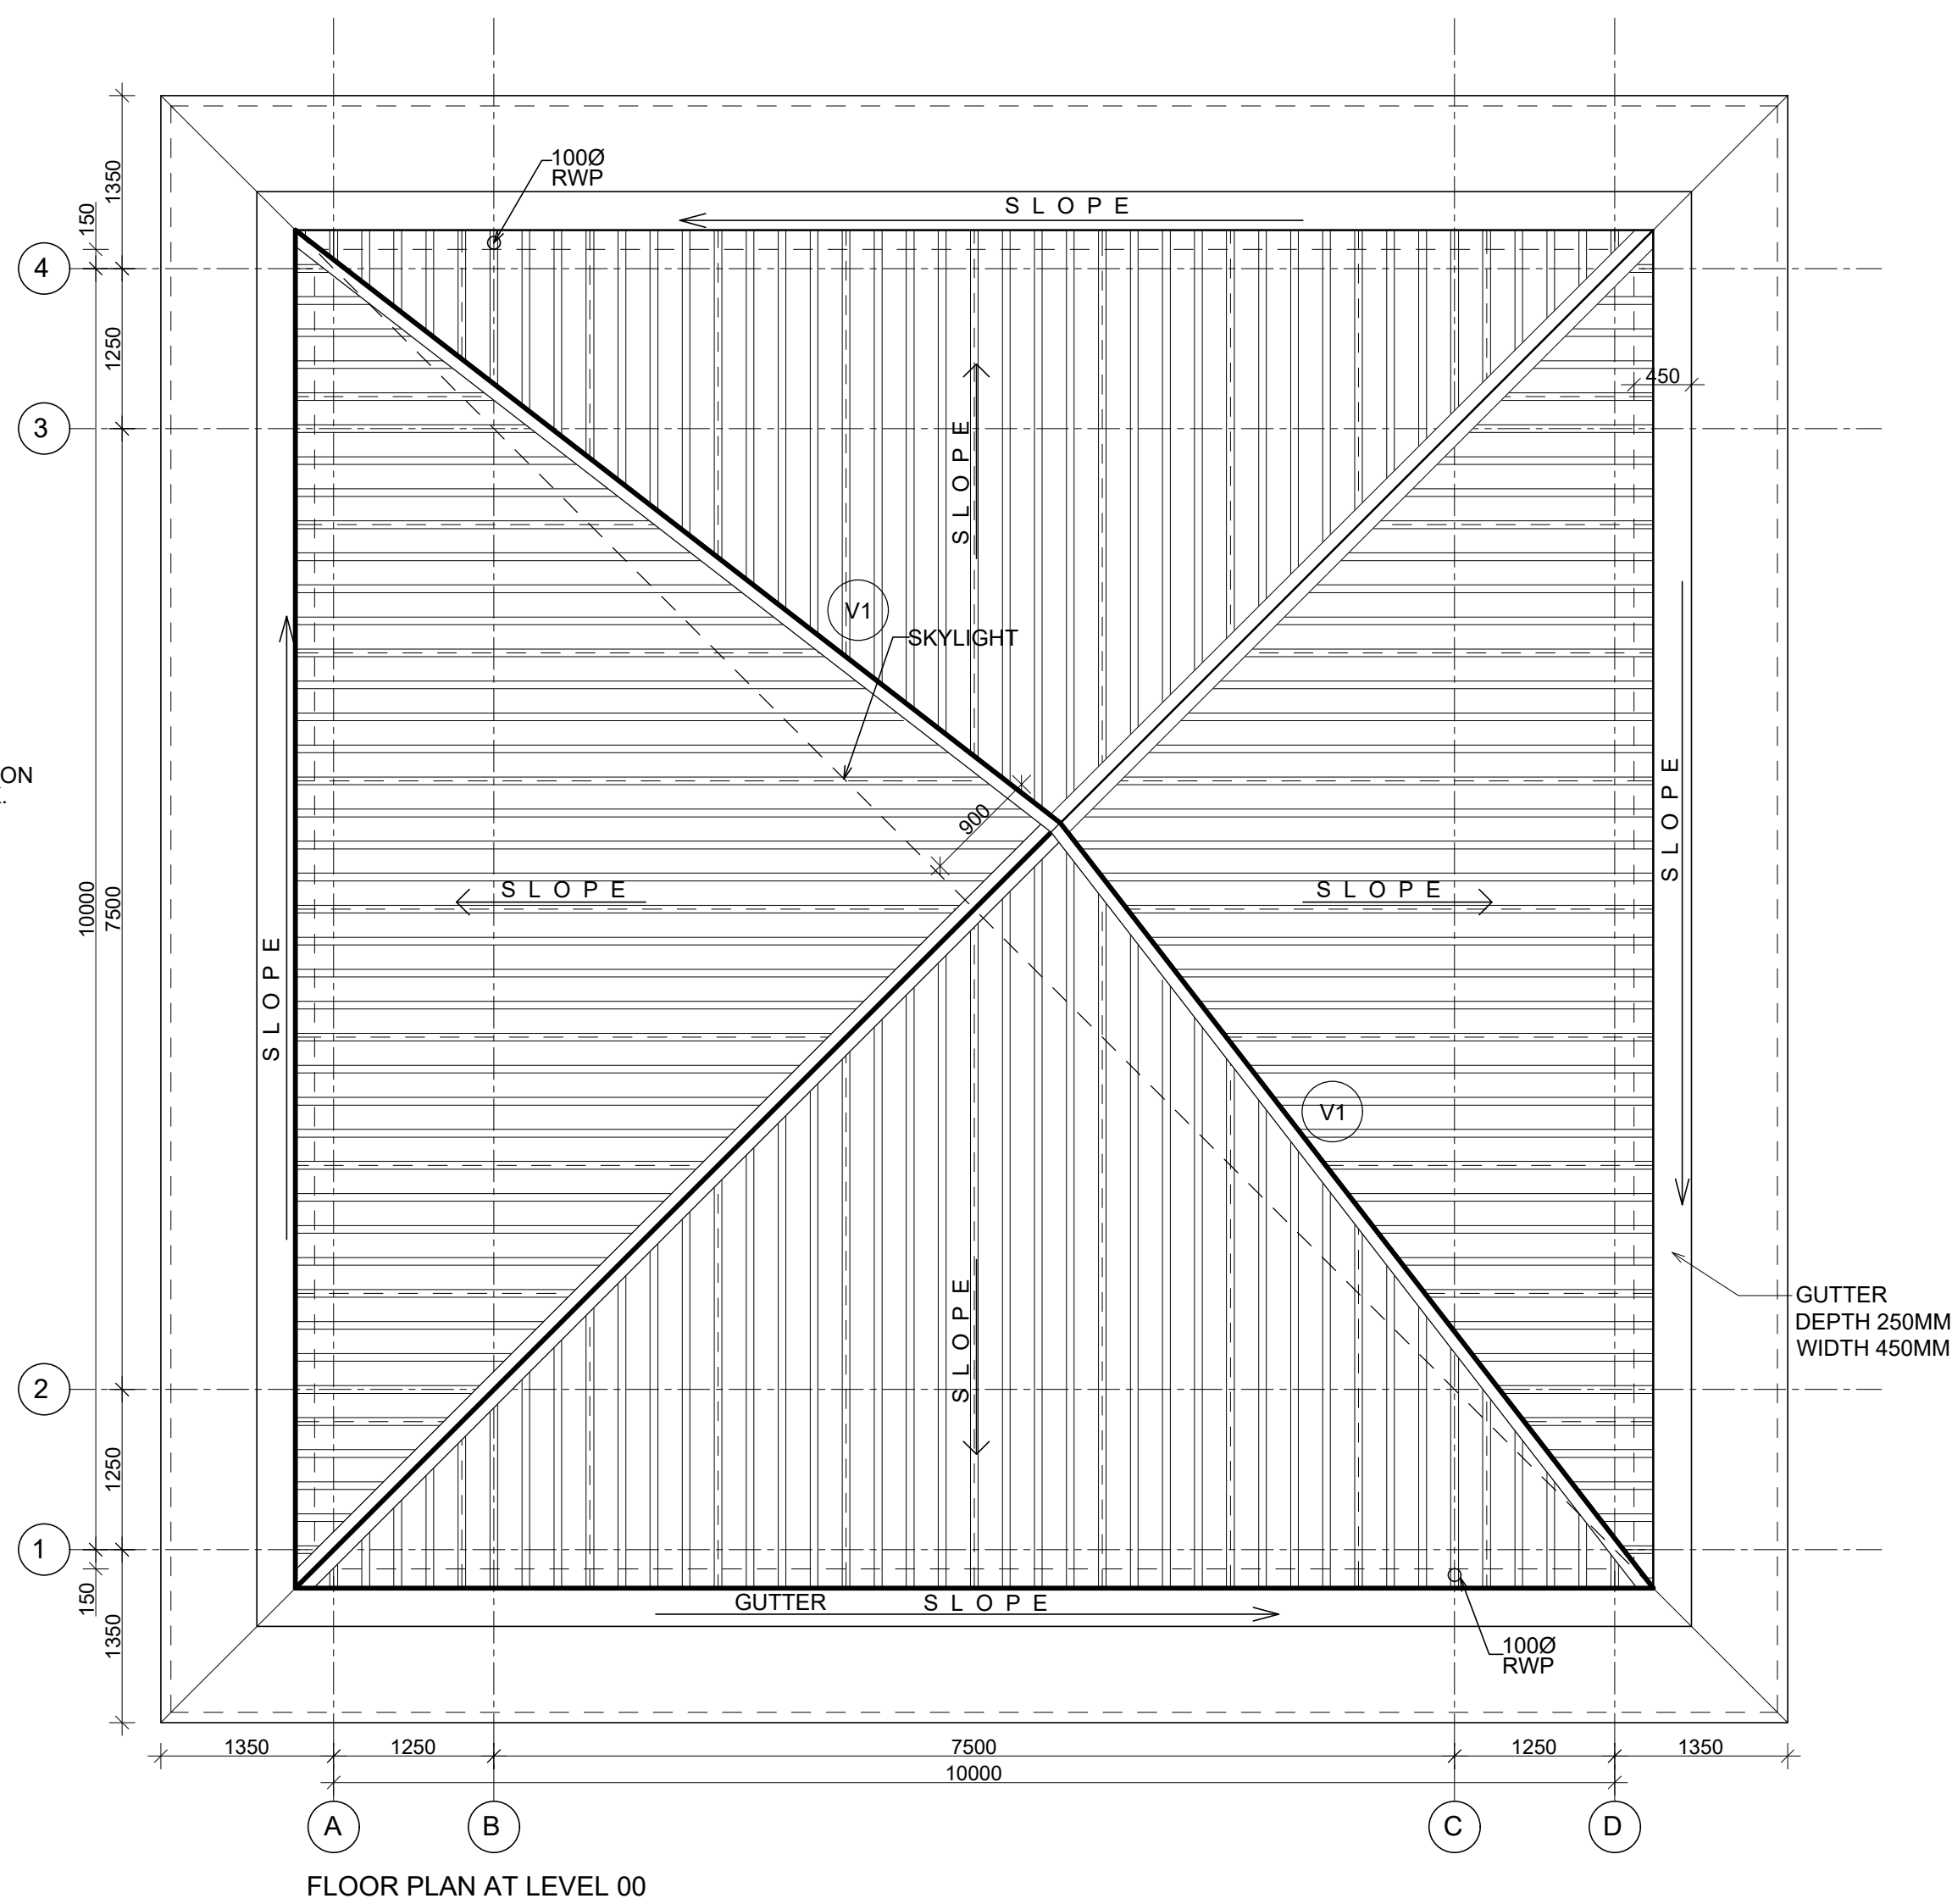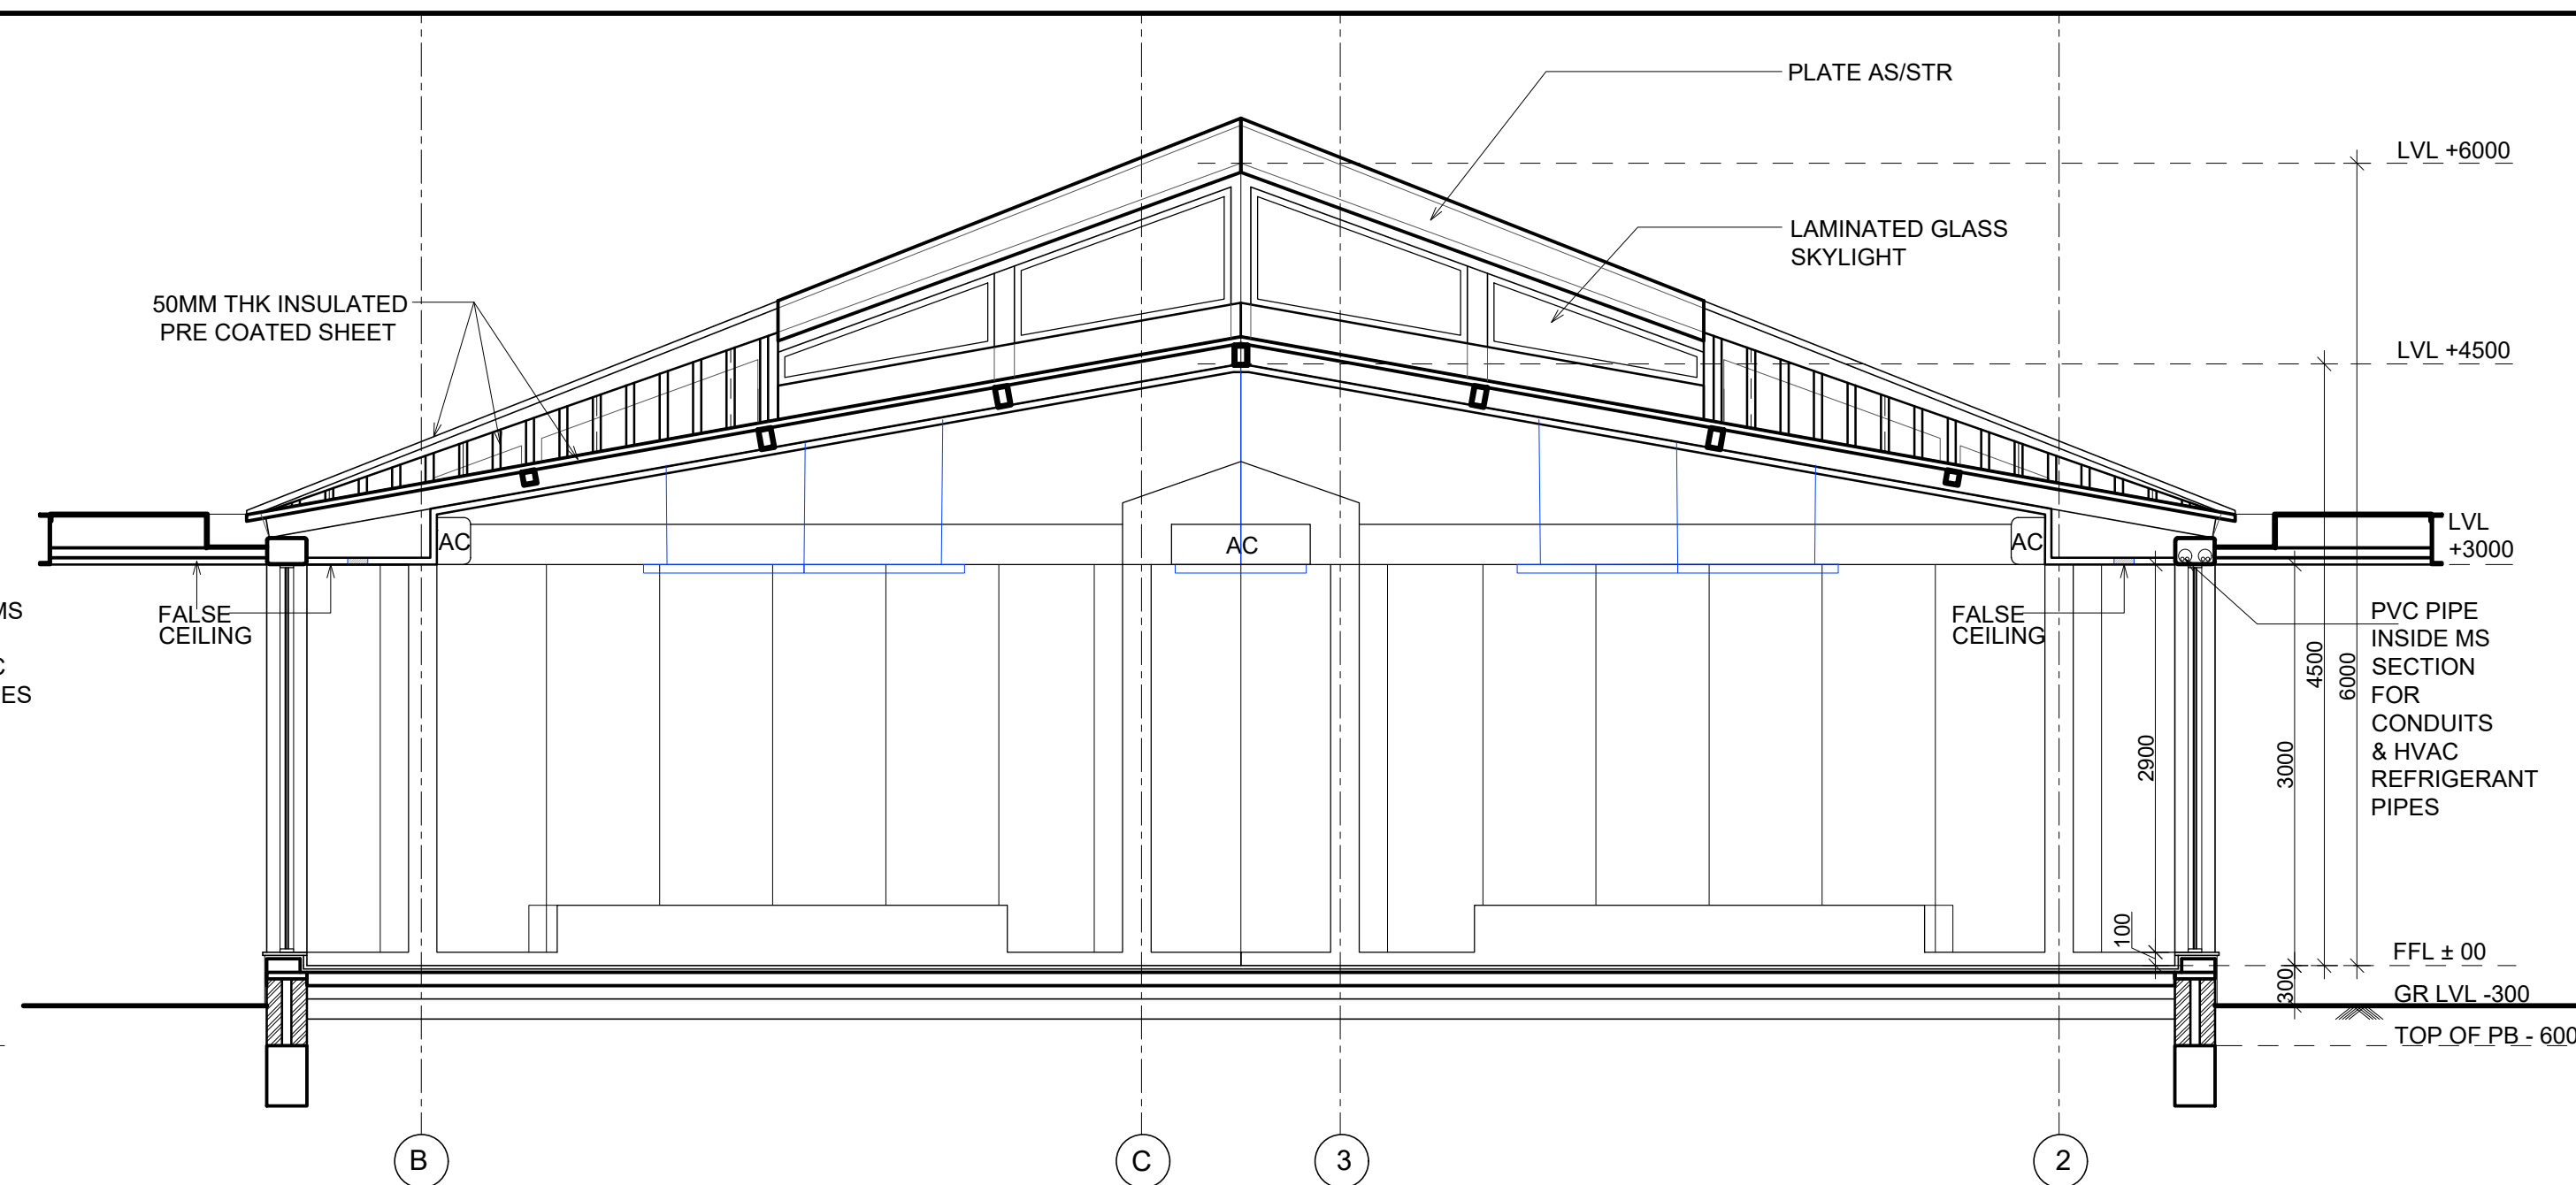

SCHEDULE OF OPENINGS				
NAME	WIDTH	HEIGHT	CILL	REMARKS
DOOR-WINDOW				
DW1	7300	2900	100	DOOR- 2200 WIDE FRAMELESS GLASS DOOR
DW2	7300	2550 / 2900	450 / 100	DOOR- 900 WIDE
W1	7300	2550 / 2900	450 / 100	
W2	2300	2900	100	
V1	1620	Varies b/w 250 to 880	Varies b/w 4340 to 4945	

notes :
all dimensions are in mm
the contractor must verify all the dimensions on site before commencement of work
do not scale this drawing

[illegible]

kanvinde rai & chowdhury
architects & planners
14 f middle circle connaught place,
new delhi - 110 001 tel : 23312881 23313649

job title
IIT KANPUR






VISITOR'S HOSTEL
CAFE

job no.	560/ IITK/ VHCAFE	drg. no.
date	OCT 2025	110
dealt	AMOL / ANKIT	
scale	1:50	

do not scale this drawing



job no.	580/ IITK/ VHCAFE	drg. no.
date	OCT 2025	111
dealt	AMOL / ANKIT	
scale	1:50 / 20	

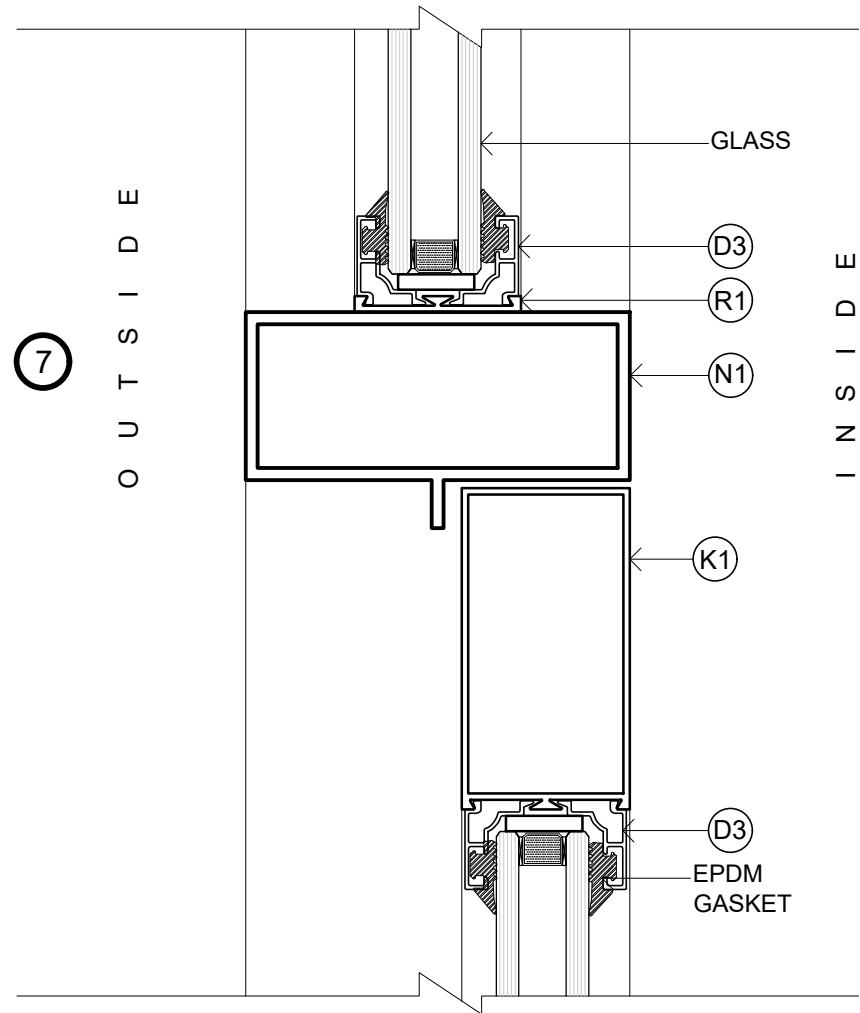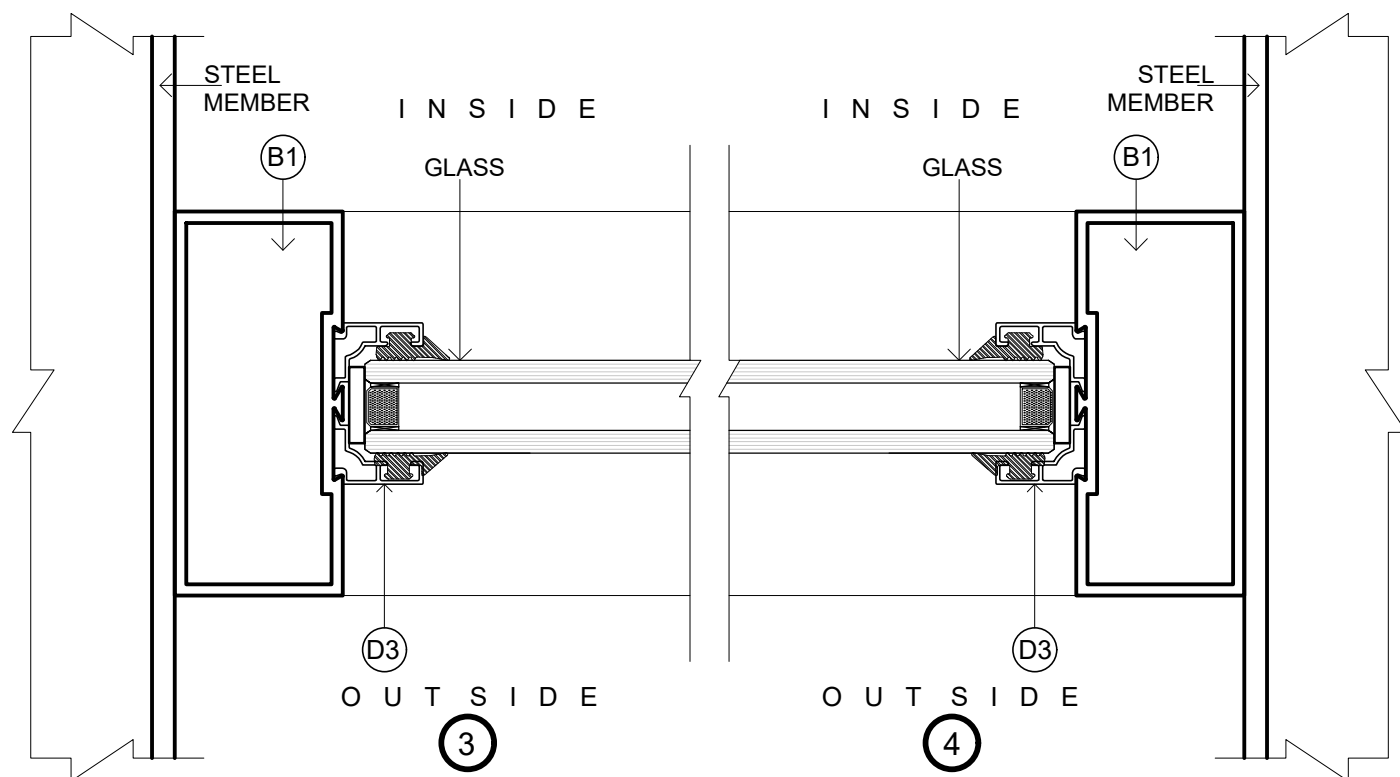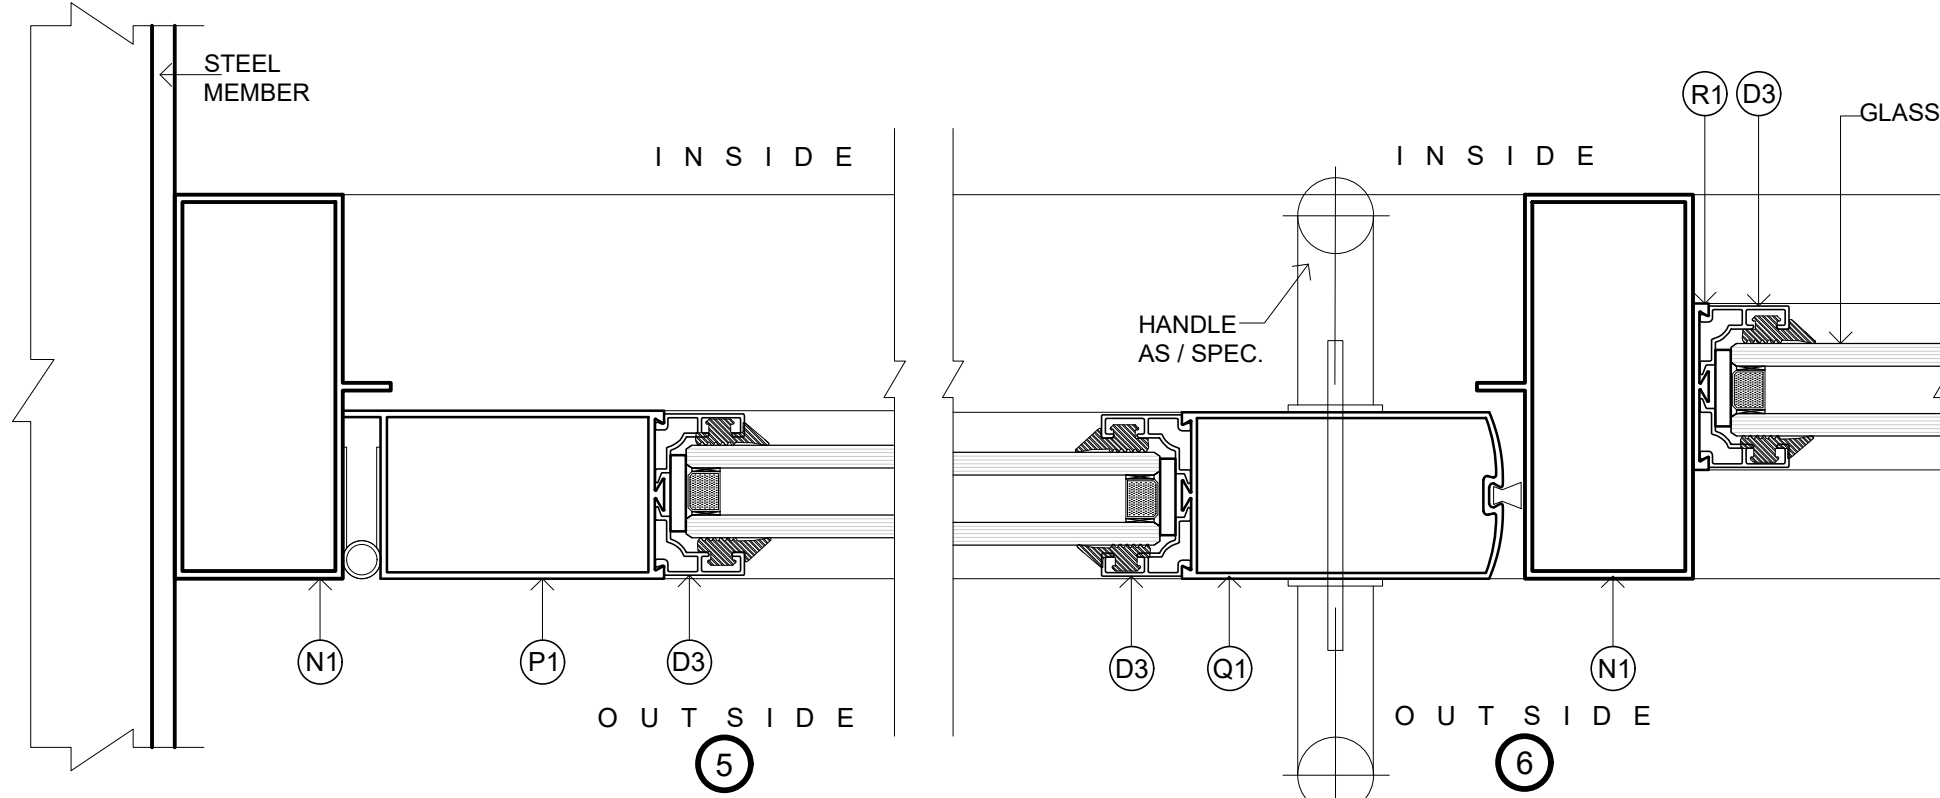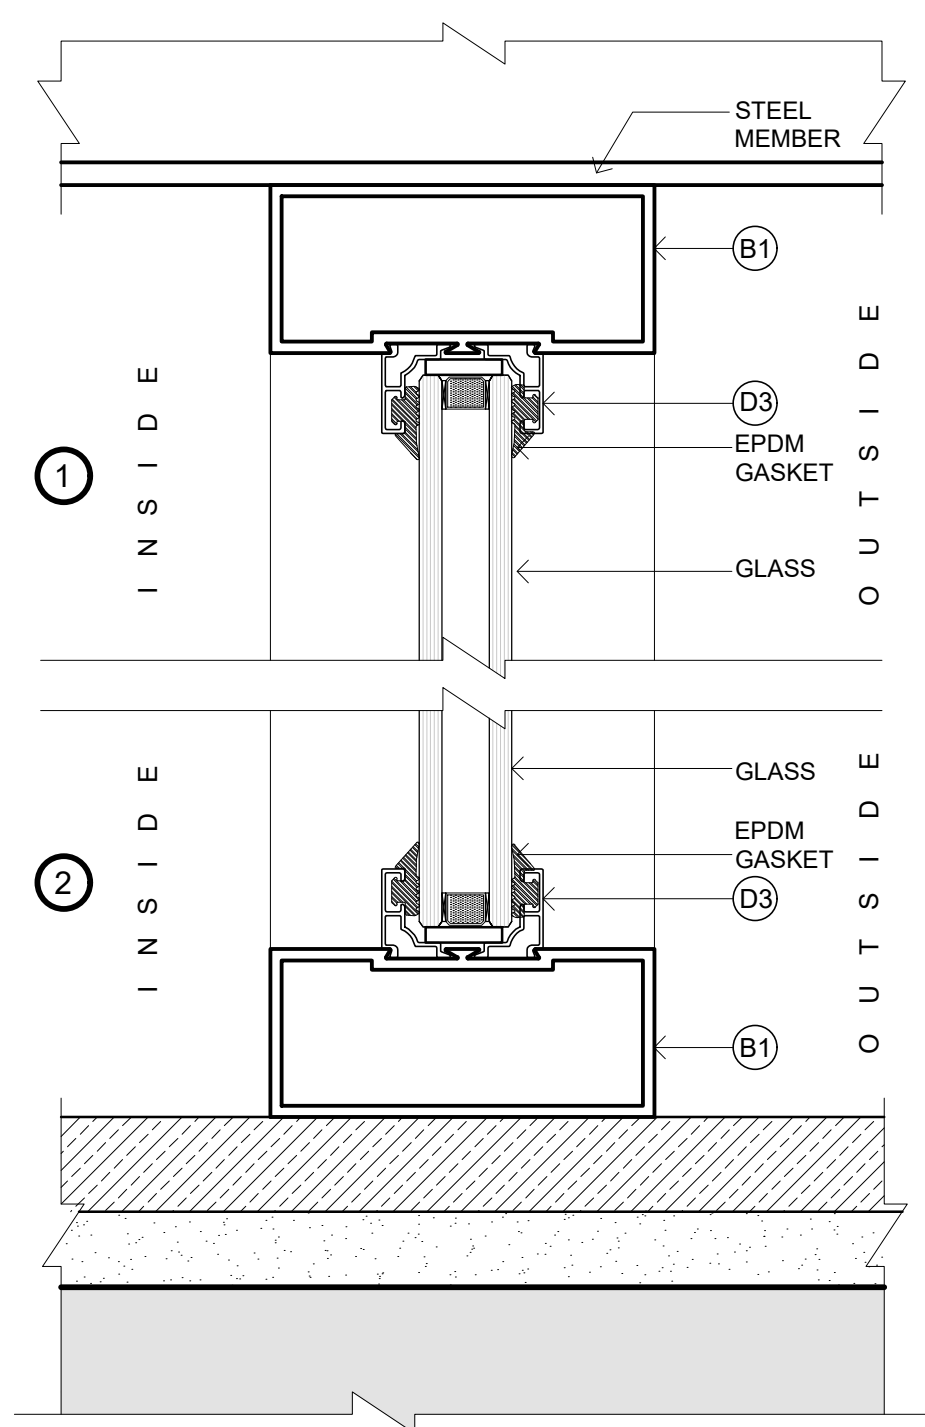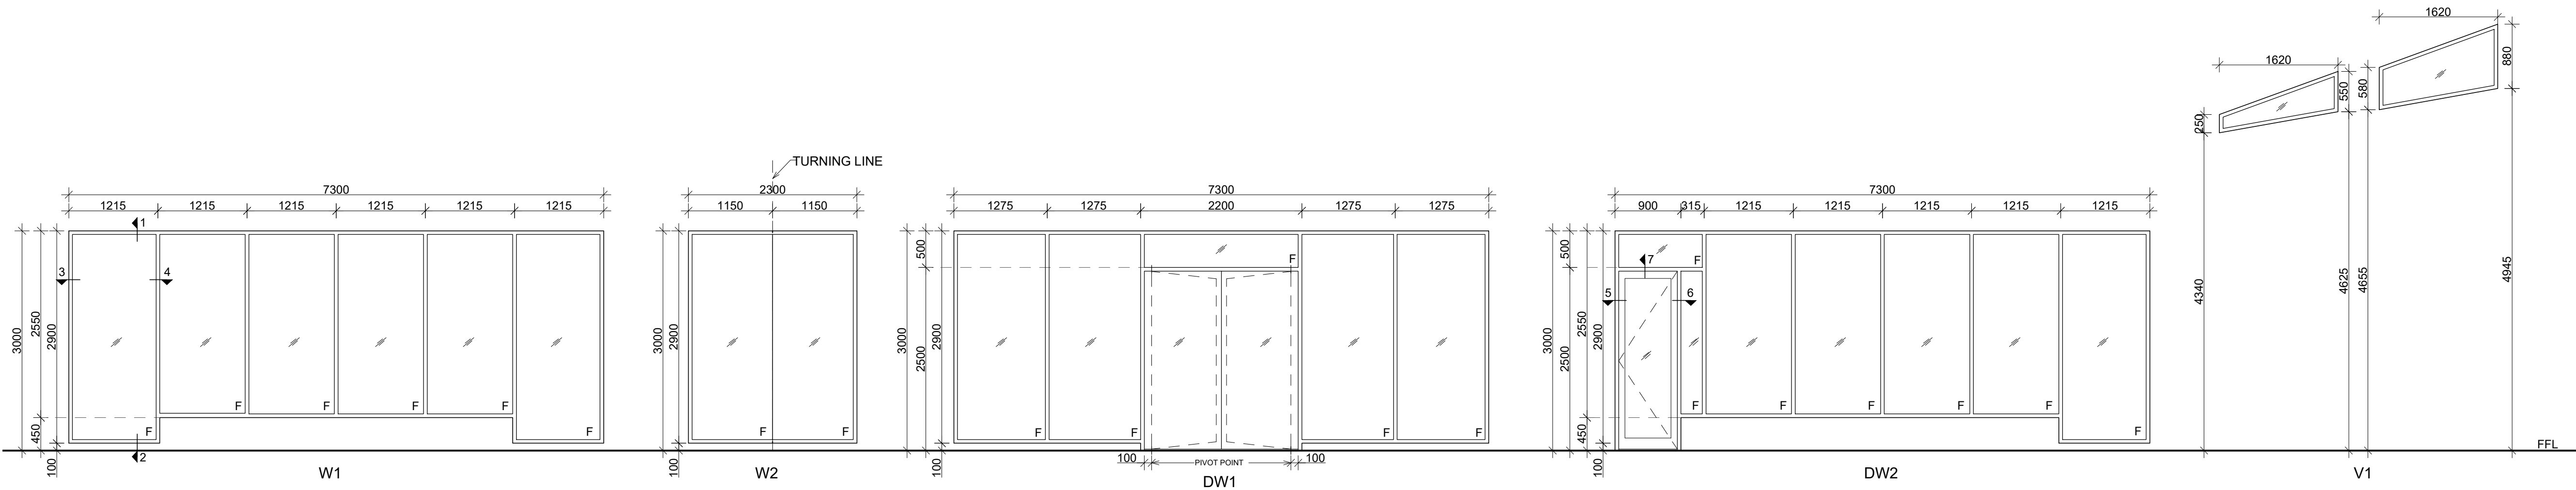

SCHEDULE OF OPENINGS				
NAME	WIDTH	HEIGHT	CILL	REMARKS
DOOR-WINDOW				
DW1	7300	2900	100	DOOR- 2200 WIDE FRAMELESS GLASS DOOR
DW2	7300	2550 / 2900	450 / 100	DOOR- 900 WIDE
W1	7300	2550 / 2900	450 / 100	
W2	2300	2900	100	
V1	1620	Varies b/w 250 to 880	Varies b/w 4340 to 4945	

S.NO	JINDAL SECTION NO.	WEIGHT	REMARK
B1	20011 (101.50X44.45X3.18)	2.541 Kg/M	Main frame
D3	19398 (23.50X20.00X1.00)	0.174Kg/M	Clip/ Beading for fixed glass
K1	19508 (83.50X44.45X3.00)	2.107Kg/M	Door member
N1	20008 (101.60X44.45X3.18)	2.508Kg/M	Door frame
P1	19593 (83.5x44.45x3.27)	2.172Kg/M	Door member vertical
R1	19353 (44.00X5.71X3.18)	0.453Kg/M	Glazing patti

this drawing is the property of m/s kanvinde rai & chowdhury and shall not be used or copied without their permission

notes :

all dimensions are in mm

the contractor must verify all the dimensions on site before commencement of work

do not scale this drawing

north point

key plan



revisions

date no. description

29.10.25
date no. mail TO IWD
no. issue

TENDER DRAWING

kanvinde rai & chowdhury
architects & planners

14 f middle circle connaught place,
new delhi - 110 001 tel : 23312881 23313649

job title



IIT KANPUR

sheet title





VISITOR'S HOSTEL
CAFE- SCHEDULE OF OPENINGS
& DETAILS


job no. 560/ IITK/ VHCAFE
date OCT 2025
dealt AMOL / ANKIT
scale 1:50 / 2

112

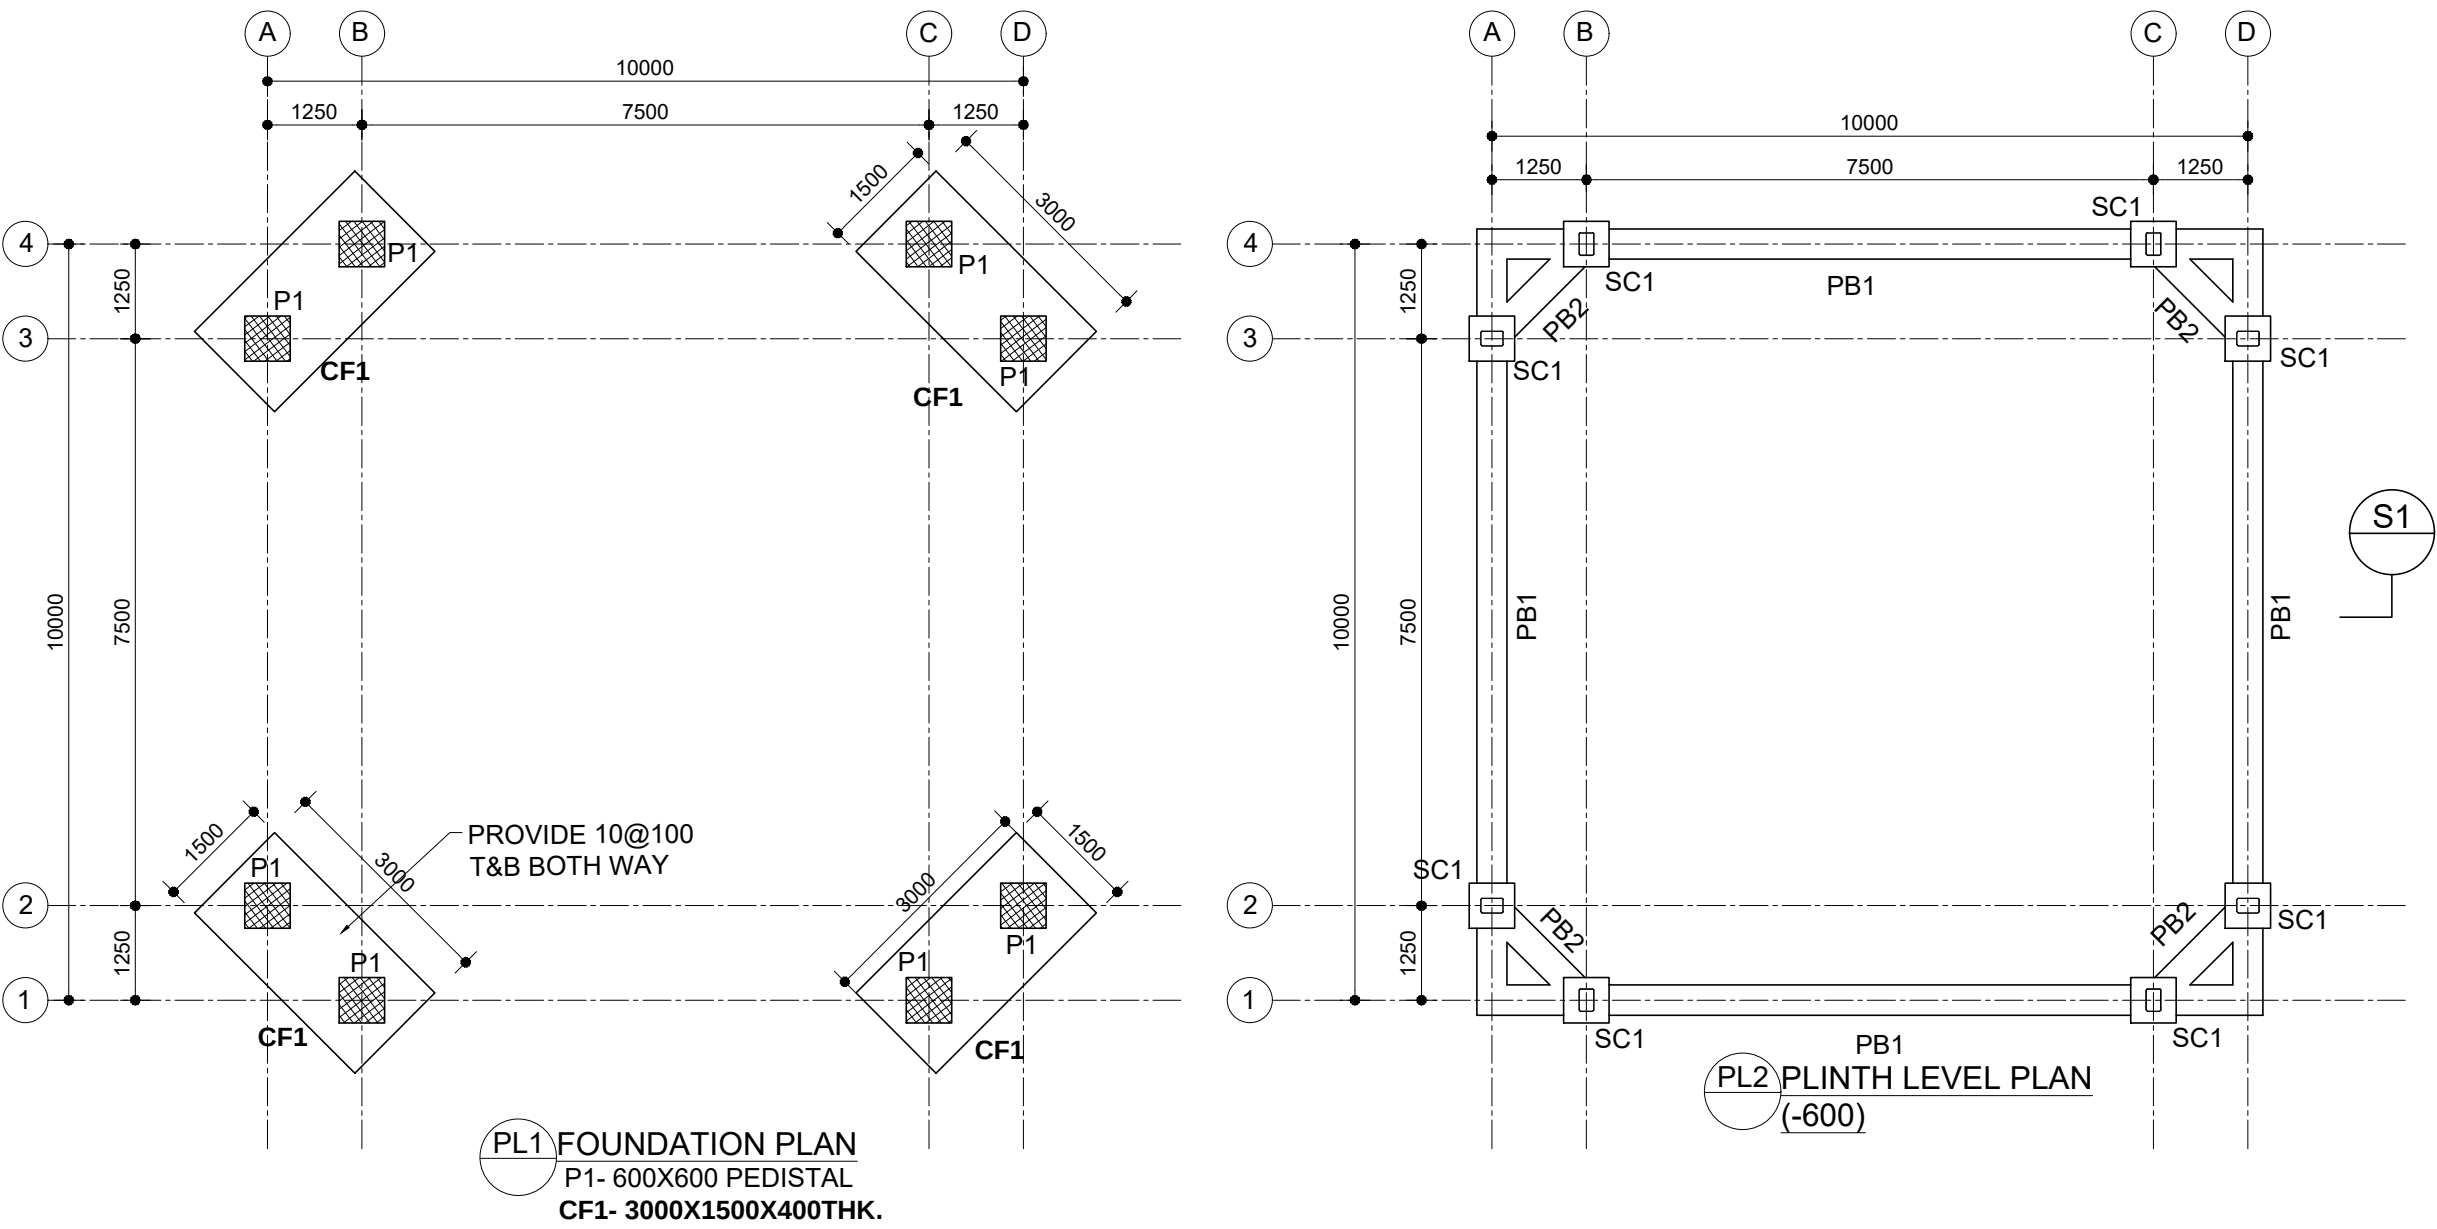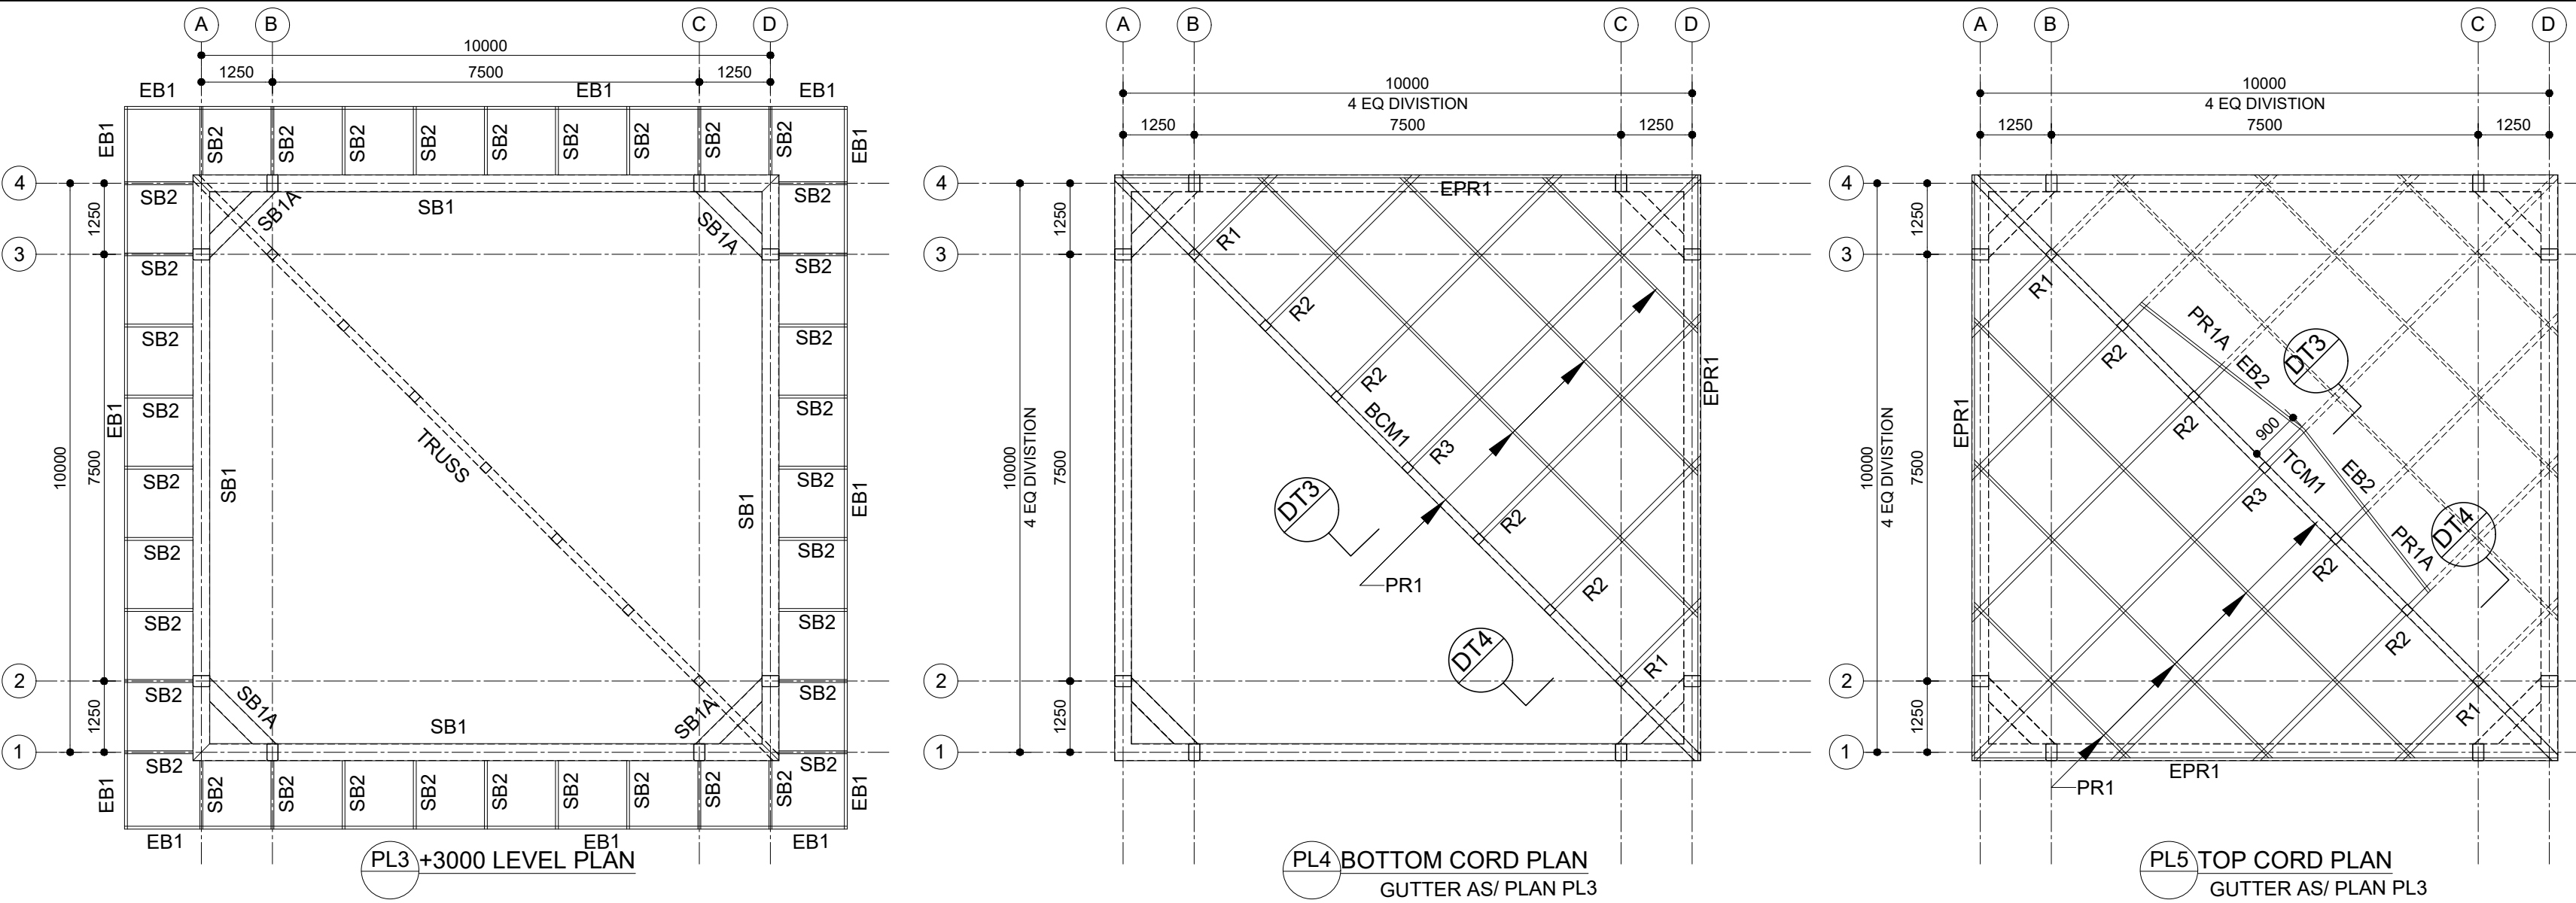


STEEL MEMBER SCHEDULE	
MARK	SIZE
SB1,SB1A	RHS 300X200X 6THK.
SB2	RHS 50X75X 4THK.
SC1	RHS 300X200X 6THK.
R1	SHS 100X100X 4THK.
R2	RHS 100X120X 4THK.
R3	RHS 100X 150 X 4THK.
PR1,1A EPR1	RHS 40X60X 3.6THK.
BCM1/ TCM1	SHS 150X150X 6THK.
VM	SHS 150X150X 6THK.
DM	SHS 100X100X 4THK.
HM	MC150
EB1	75X375 X6 TH CHANNEL
EB2	375 X6 TH CHANNEL

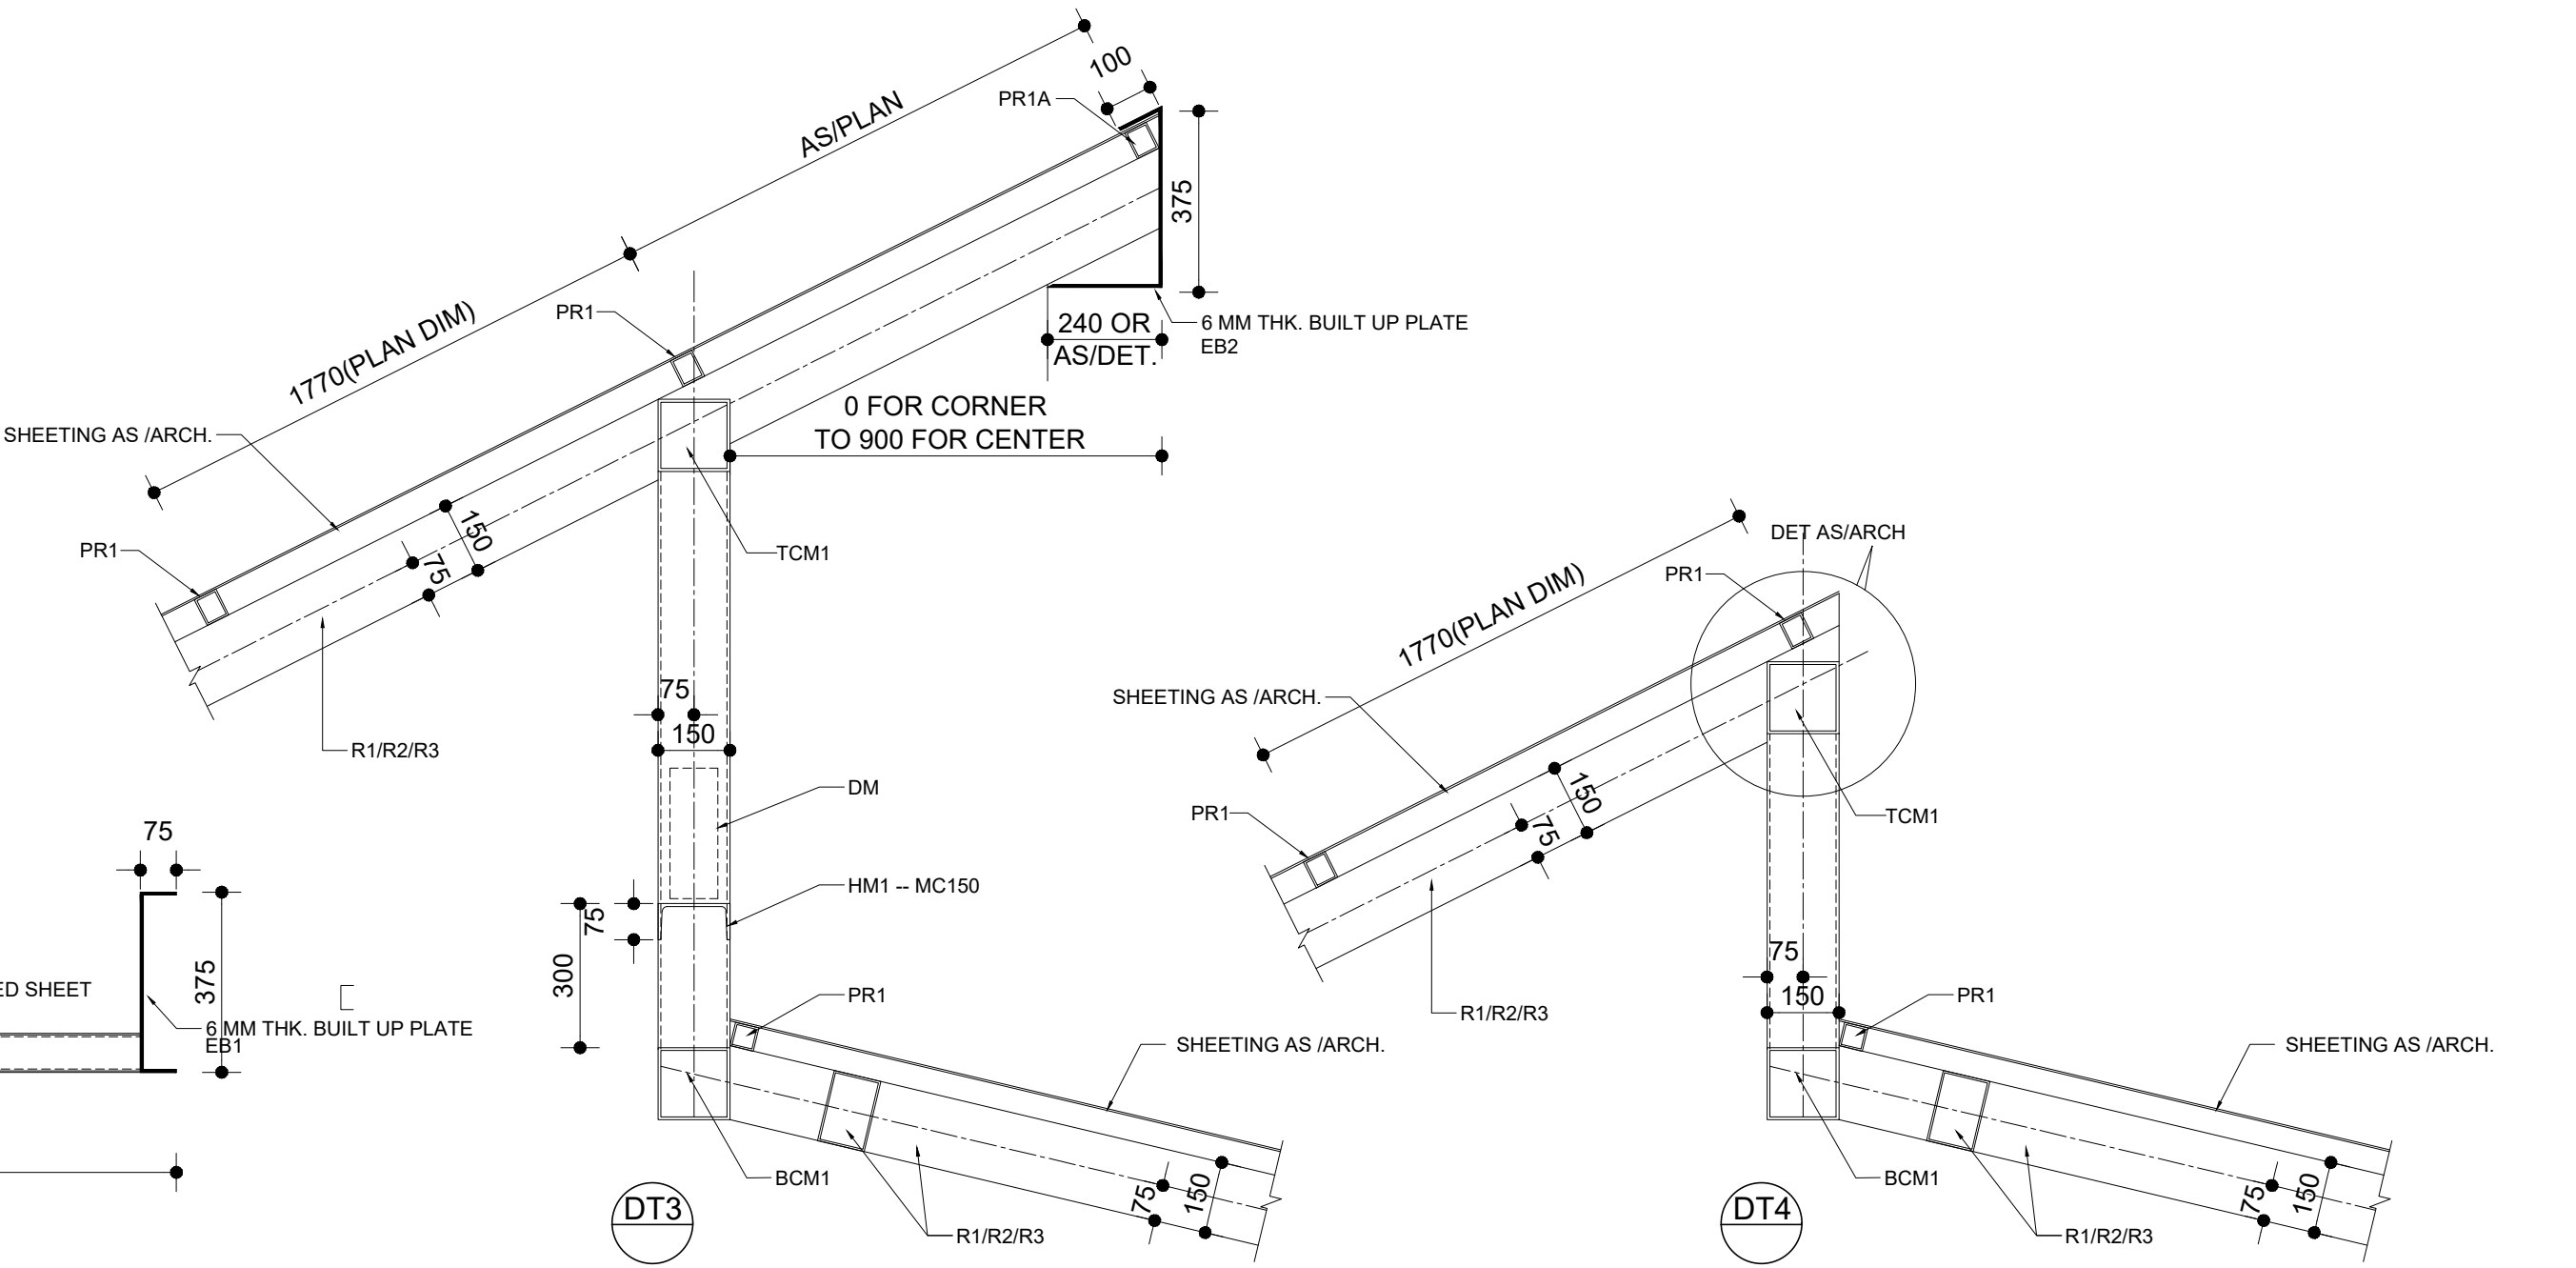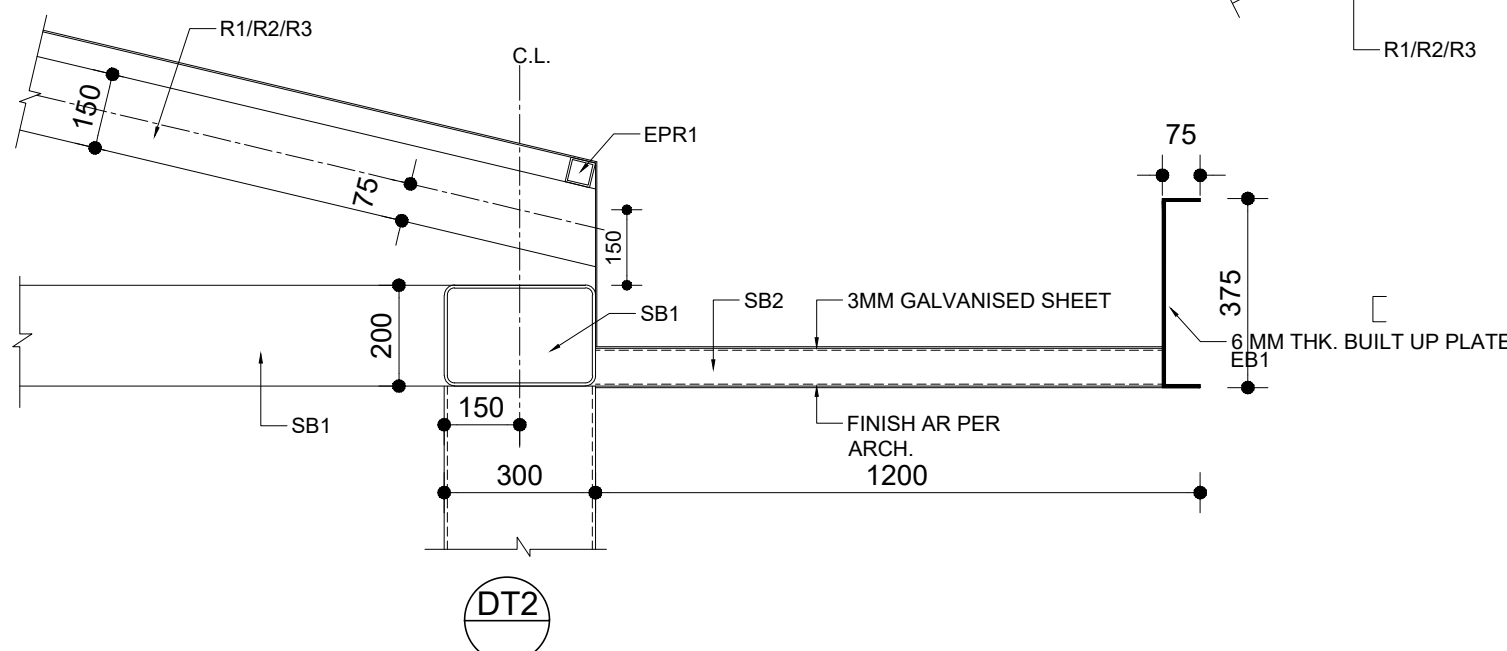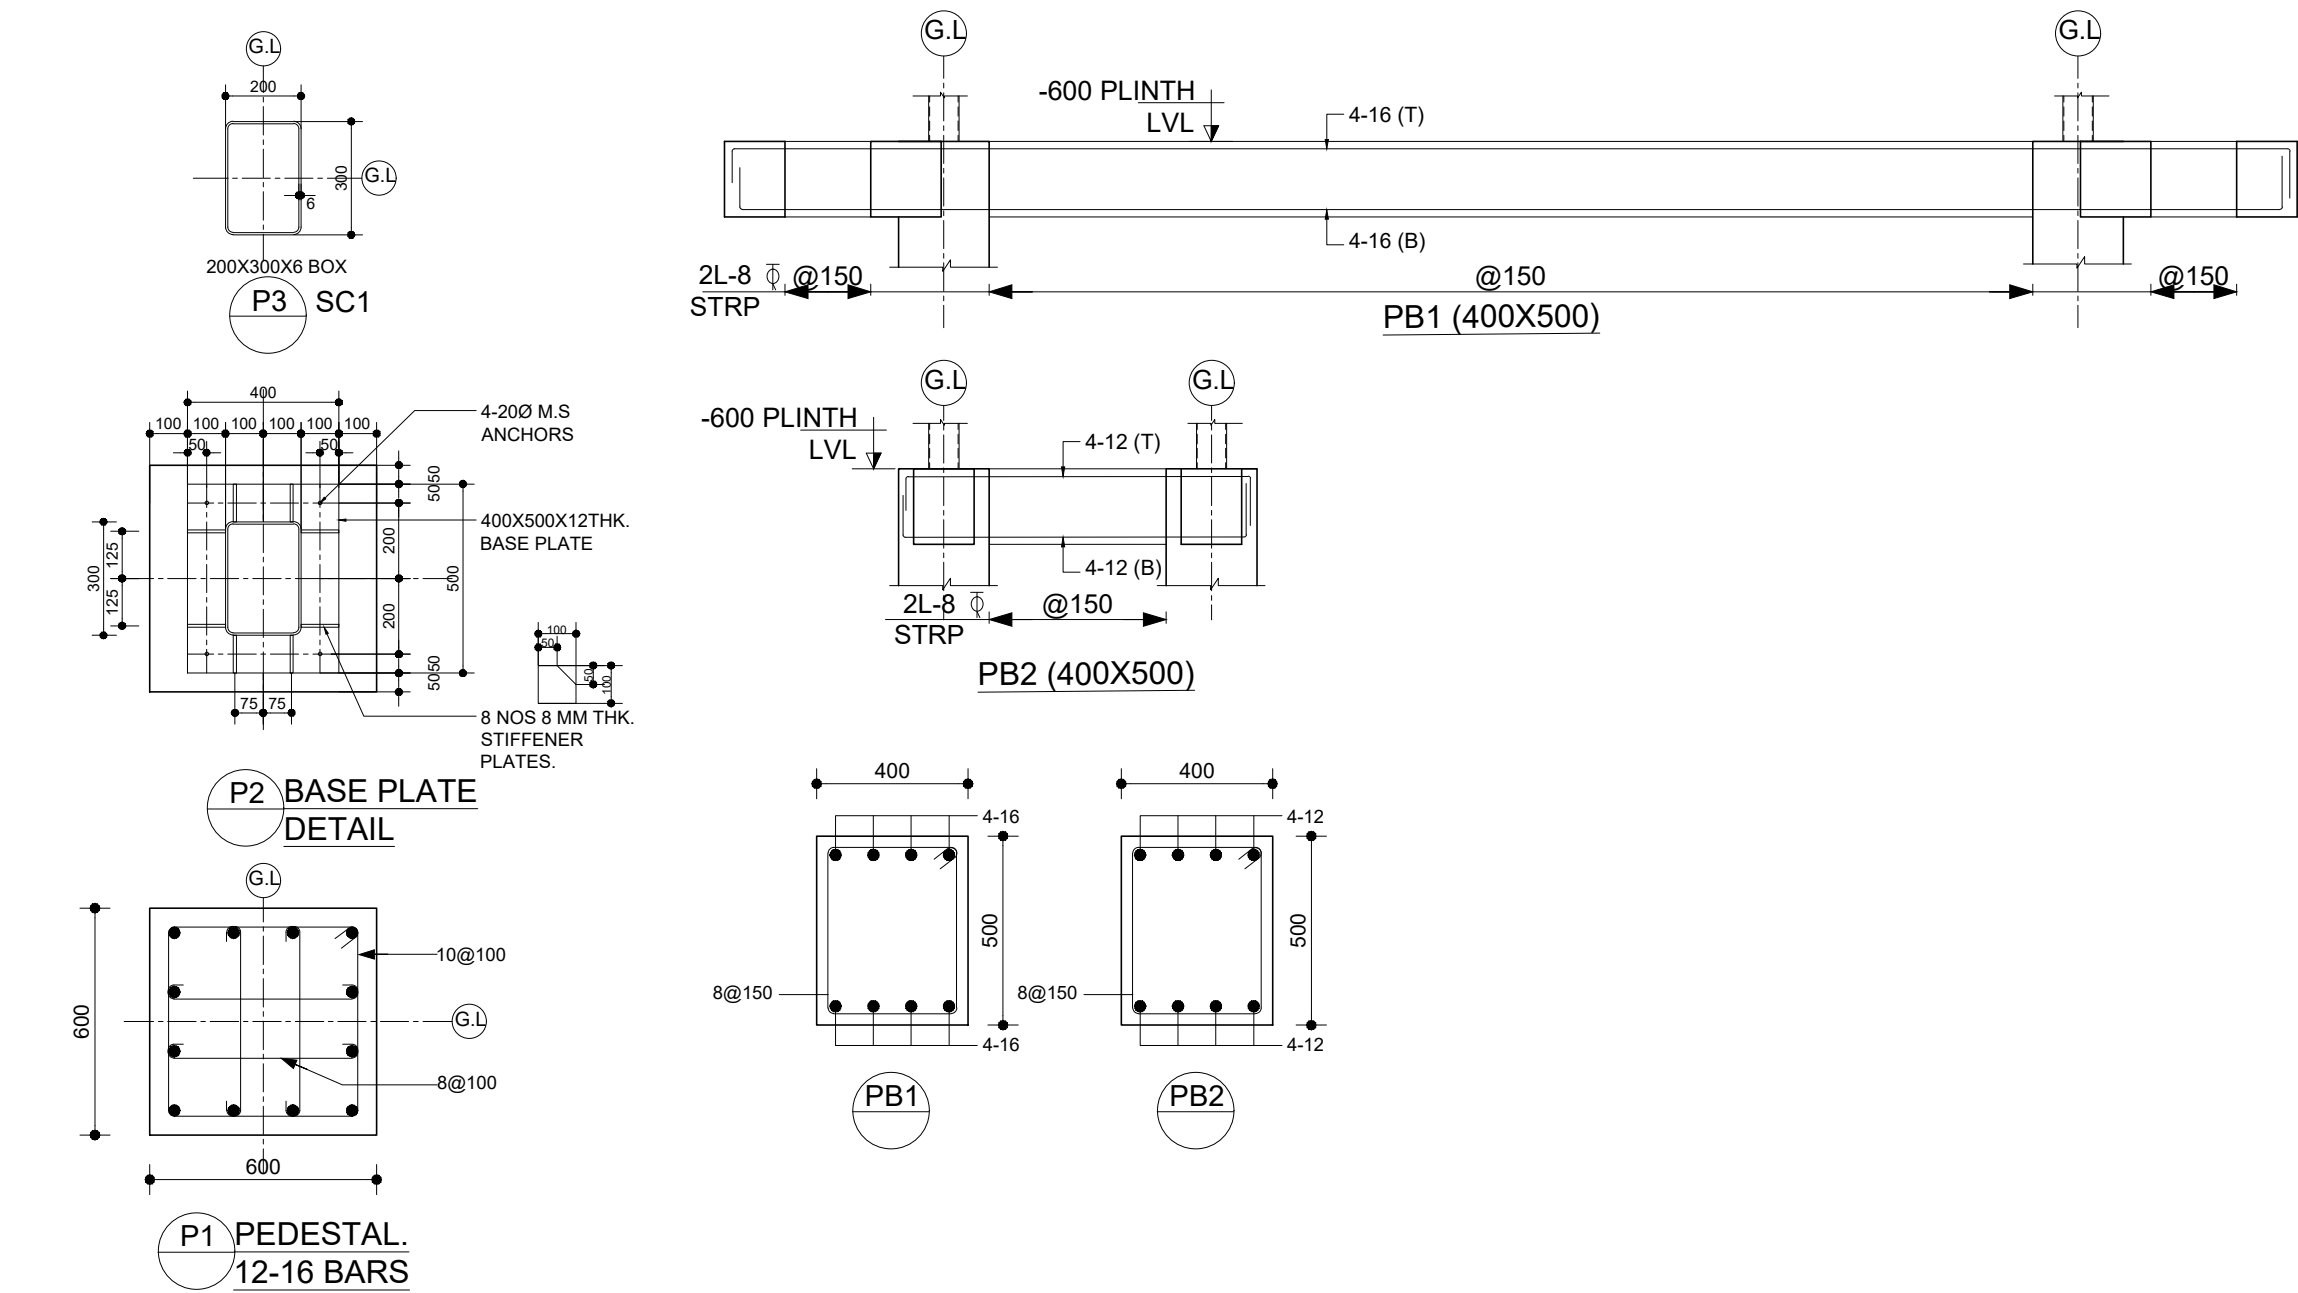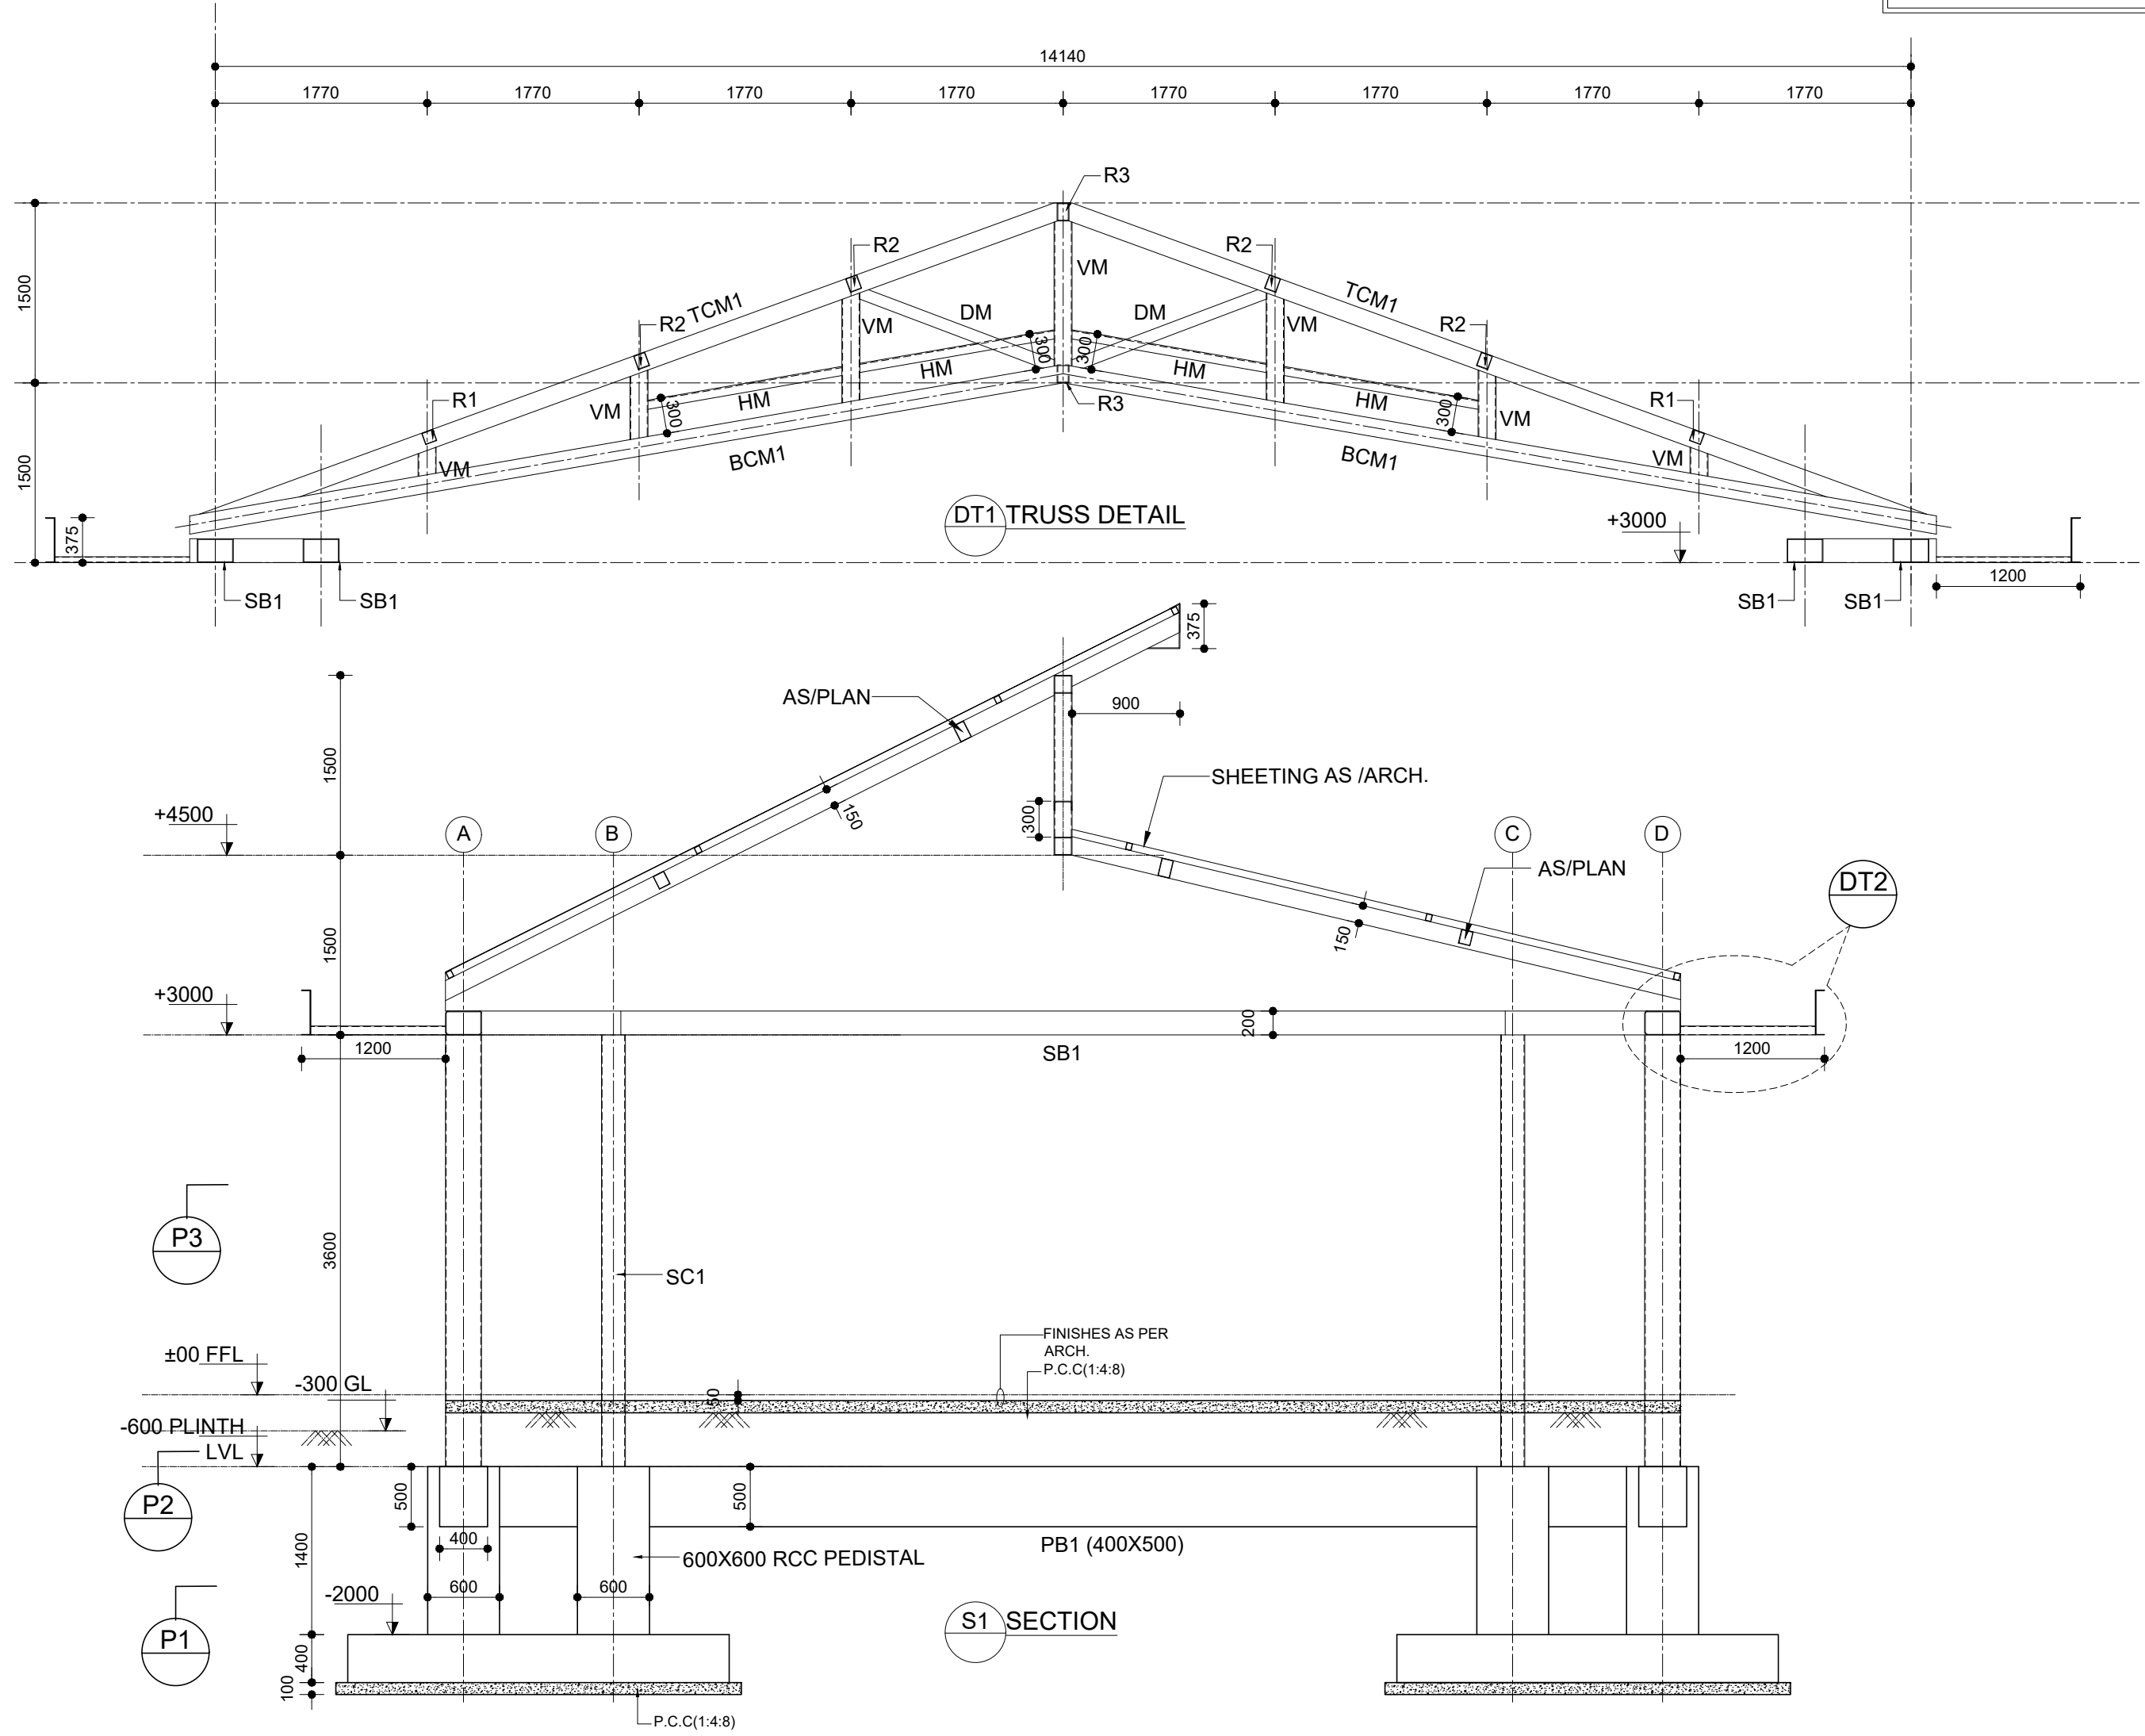


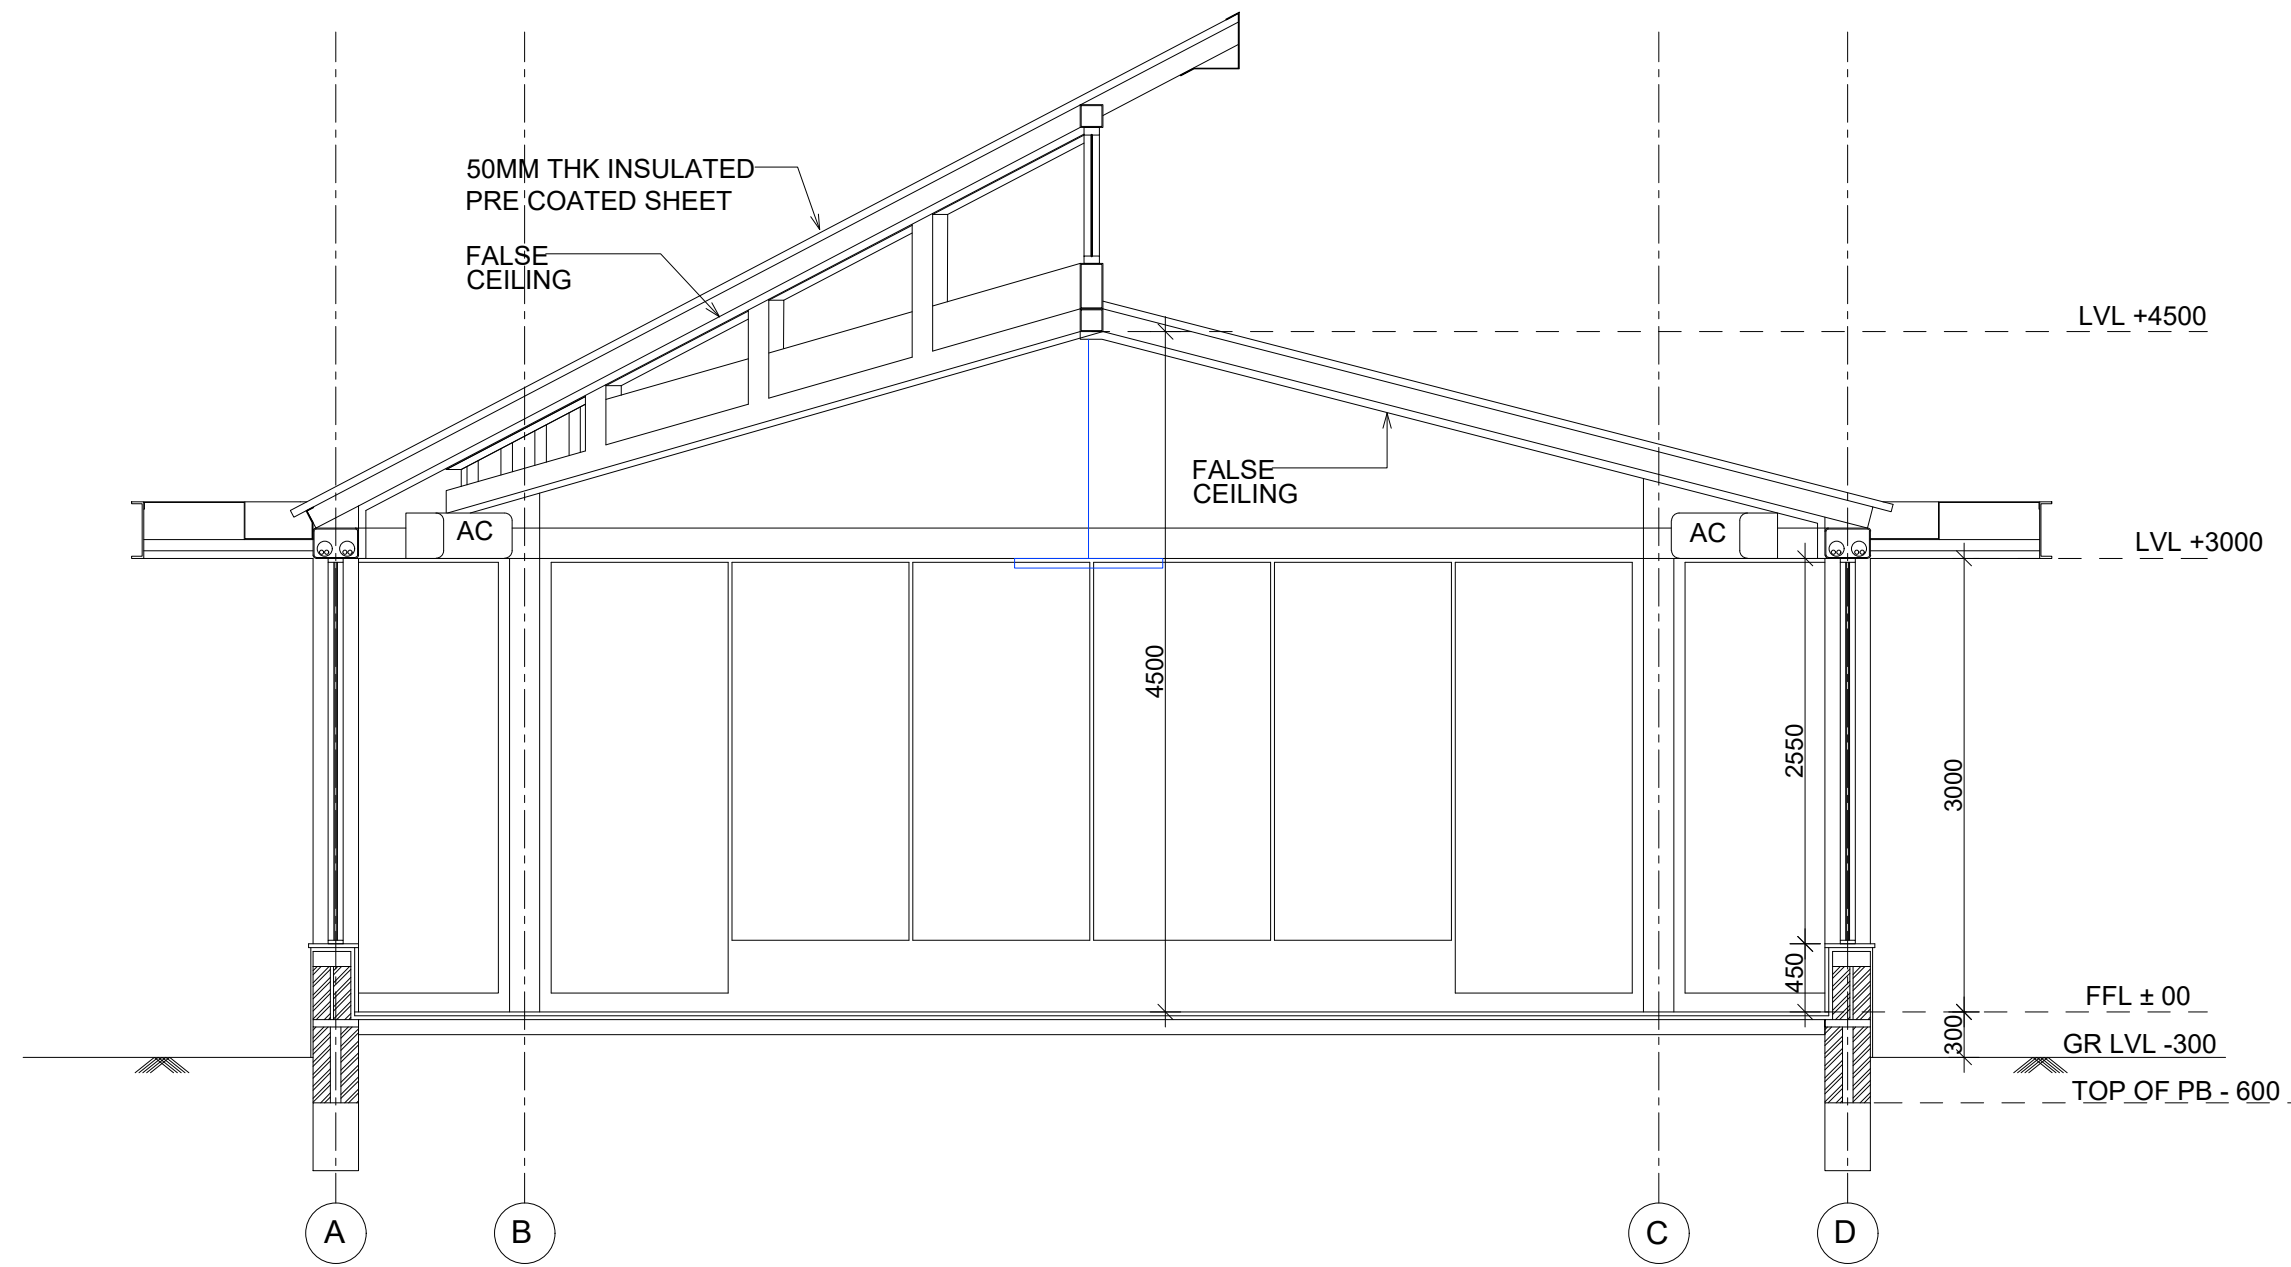


SECTION - AA

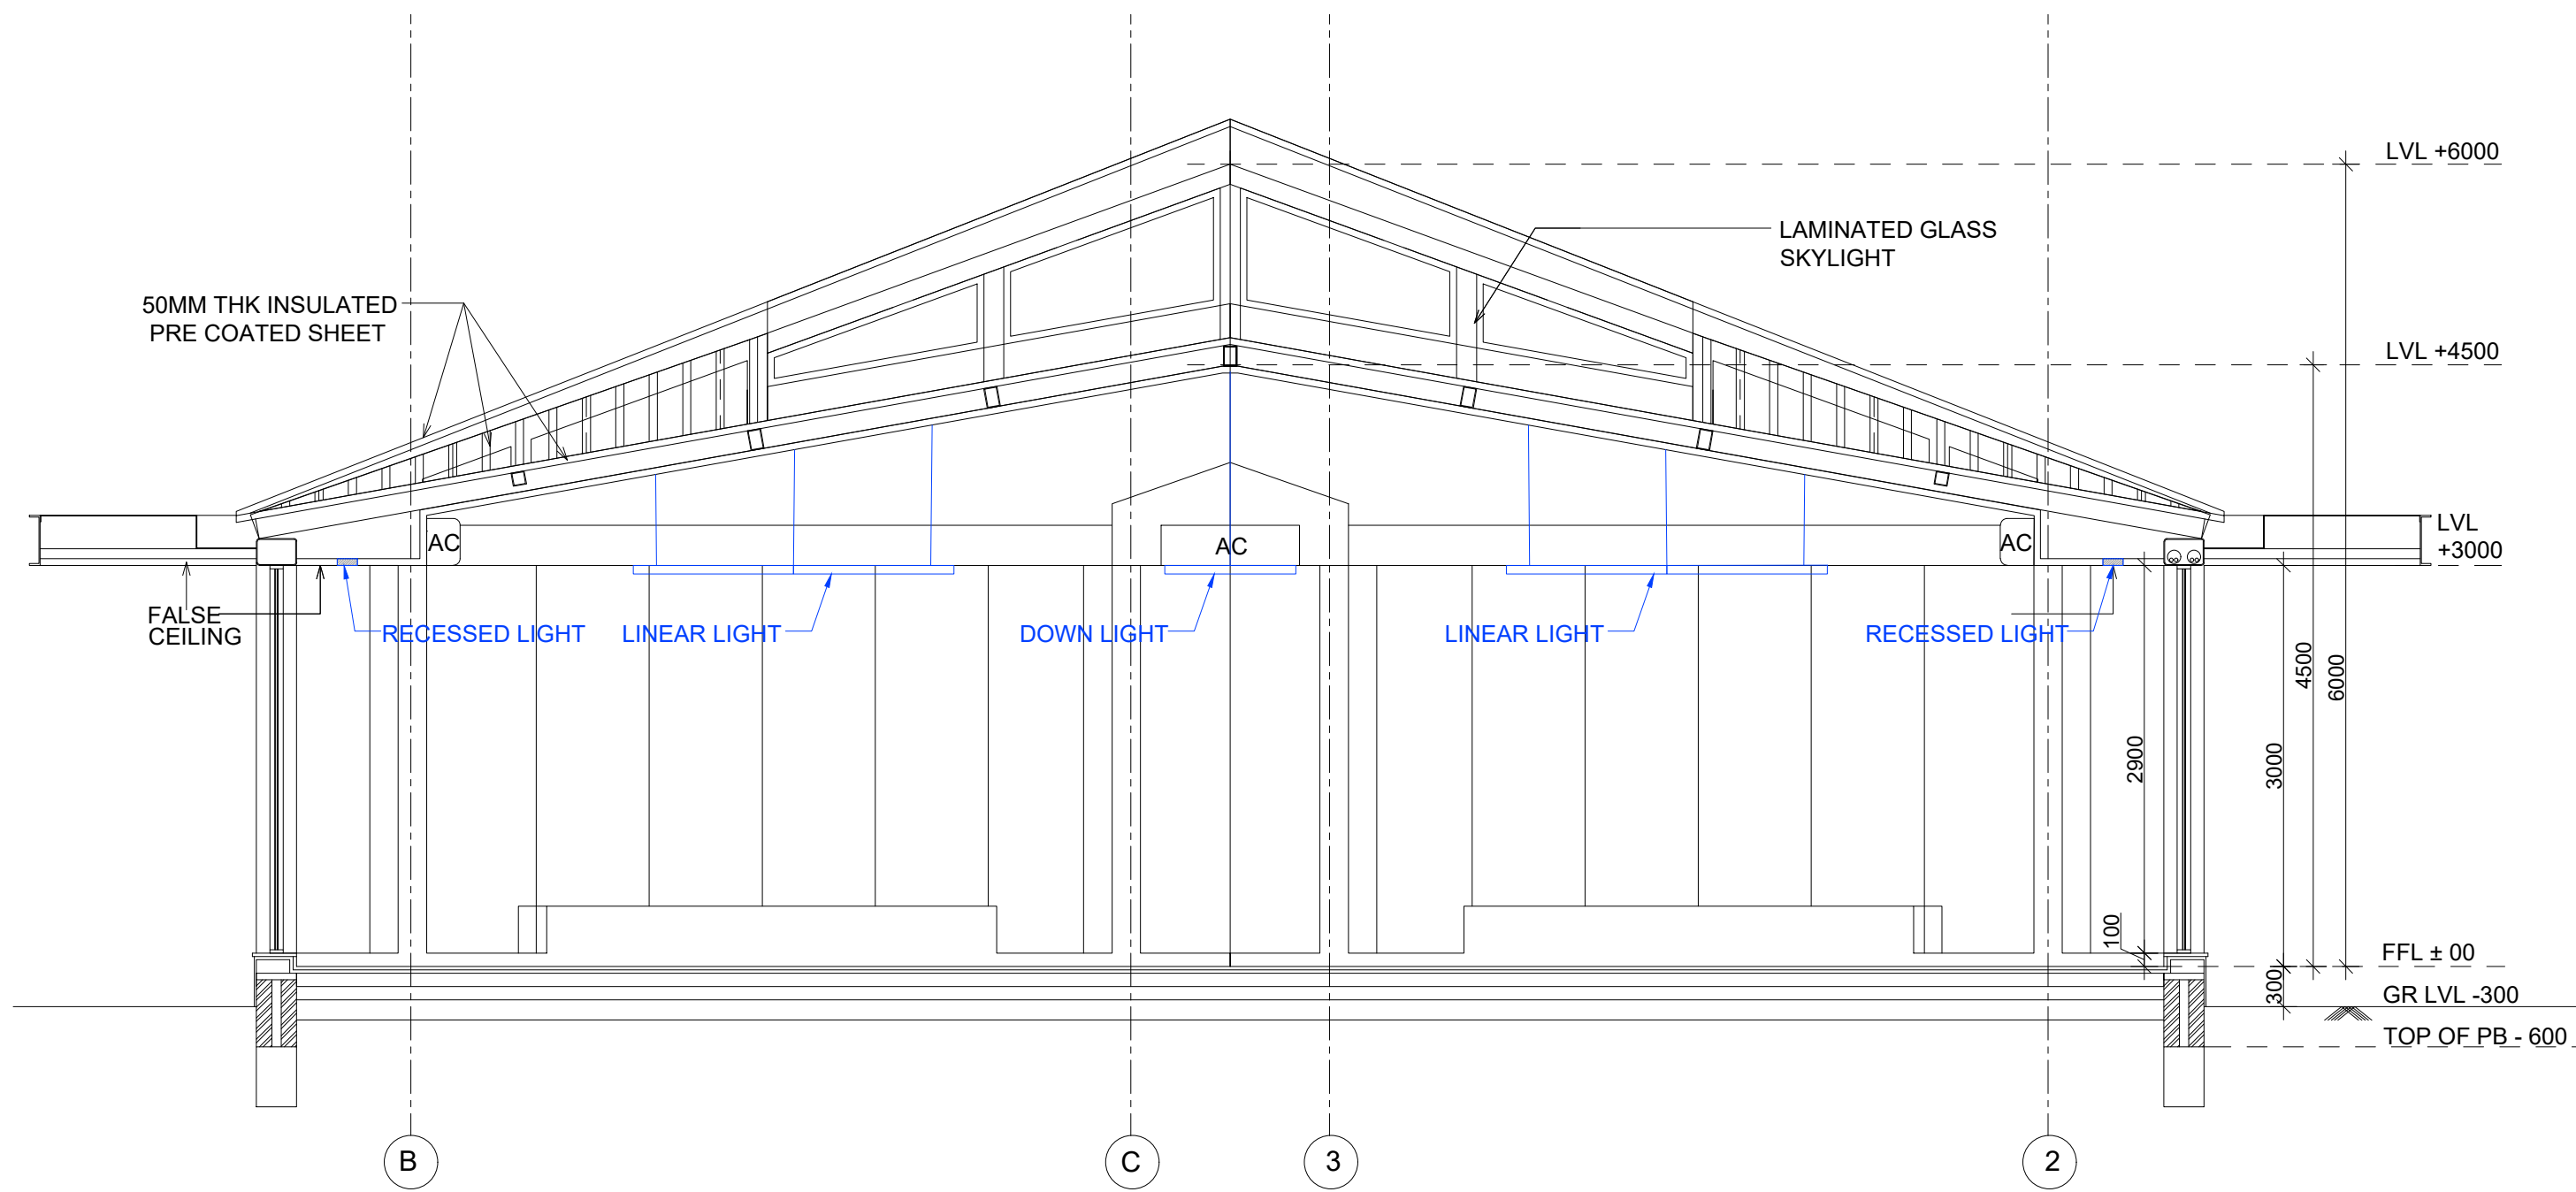

SECTION - BB

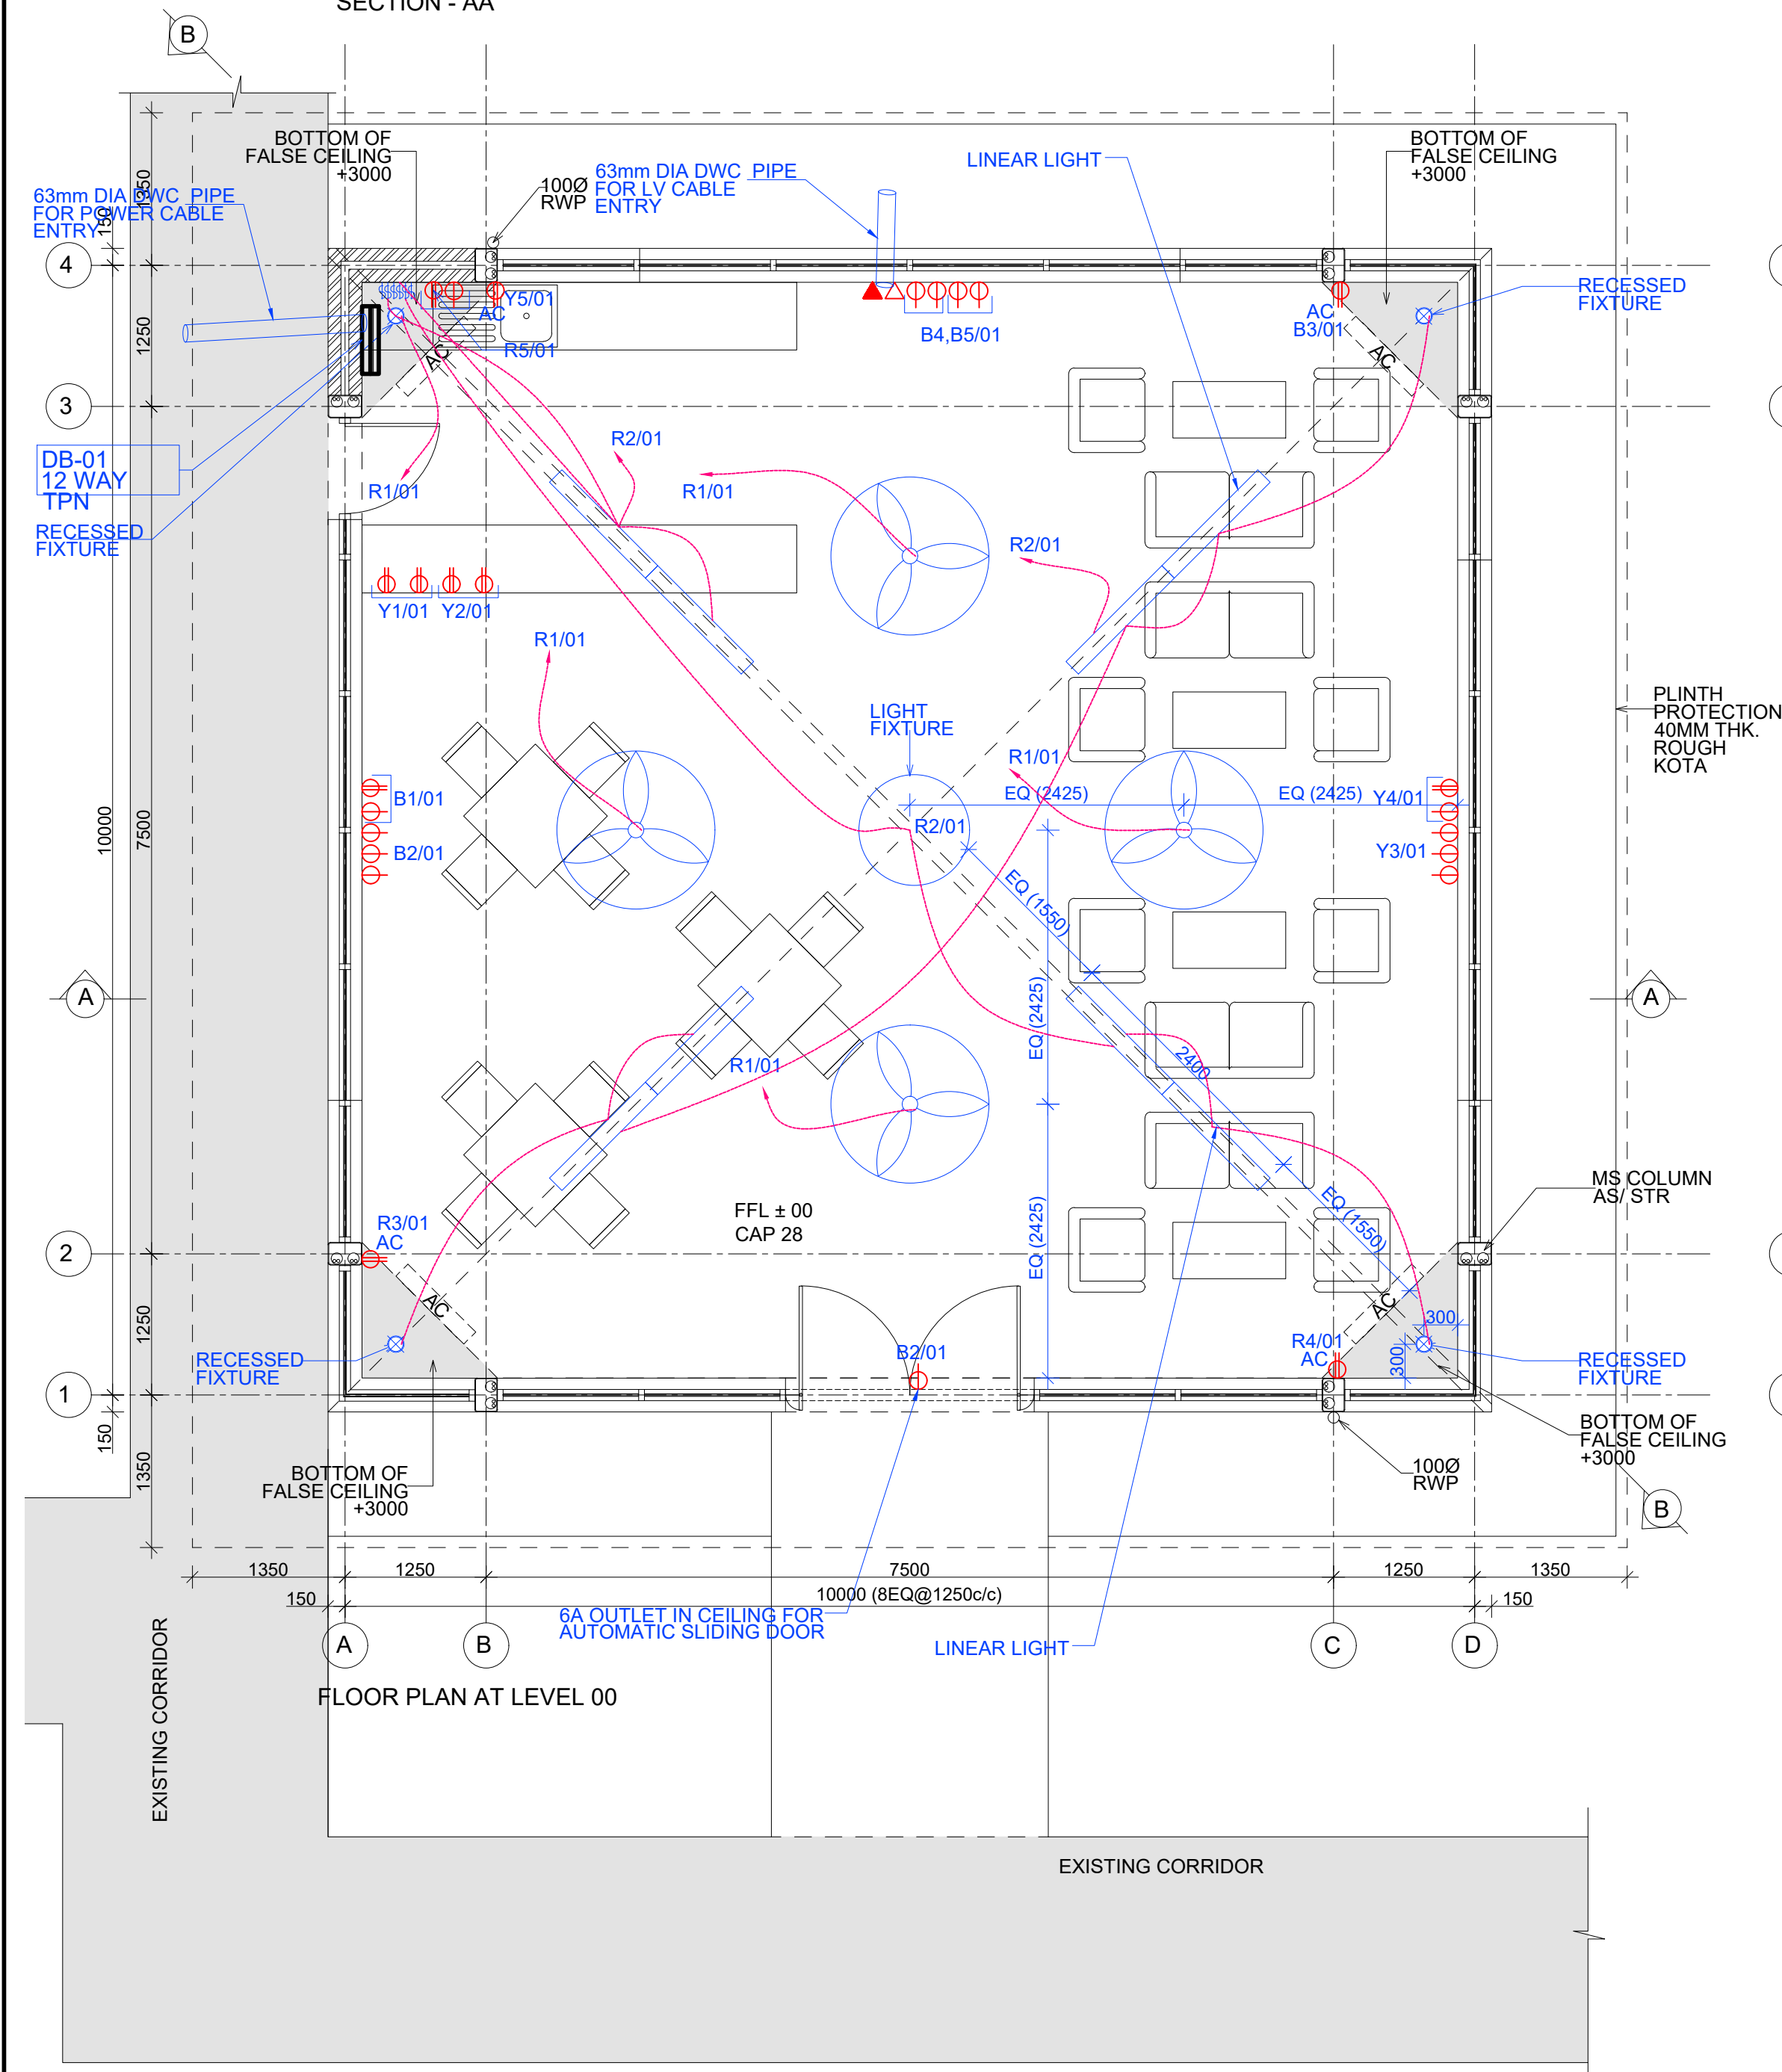

FLOOR PLAN AT LEVEL 00

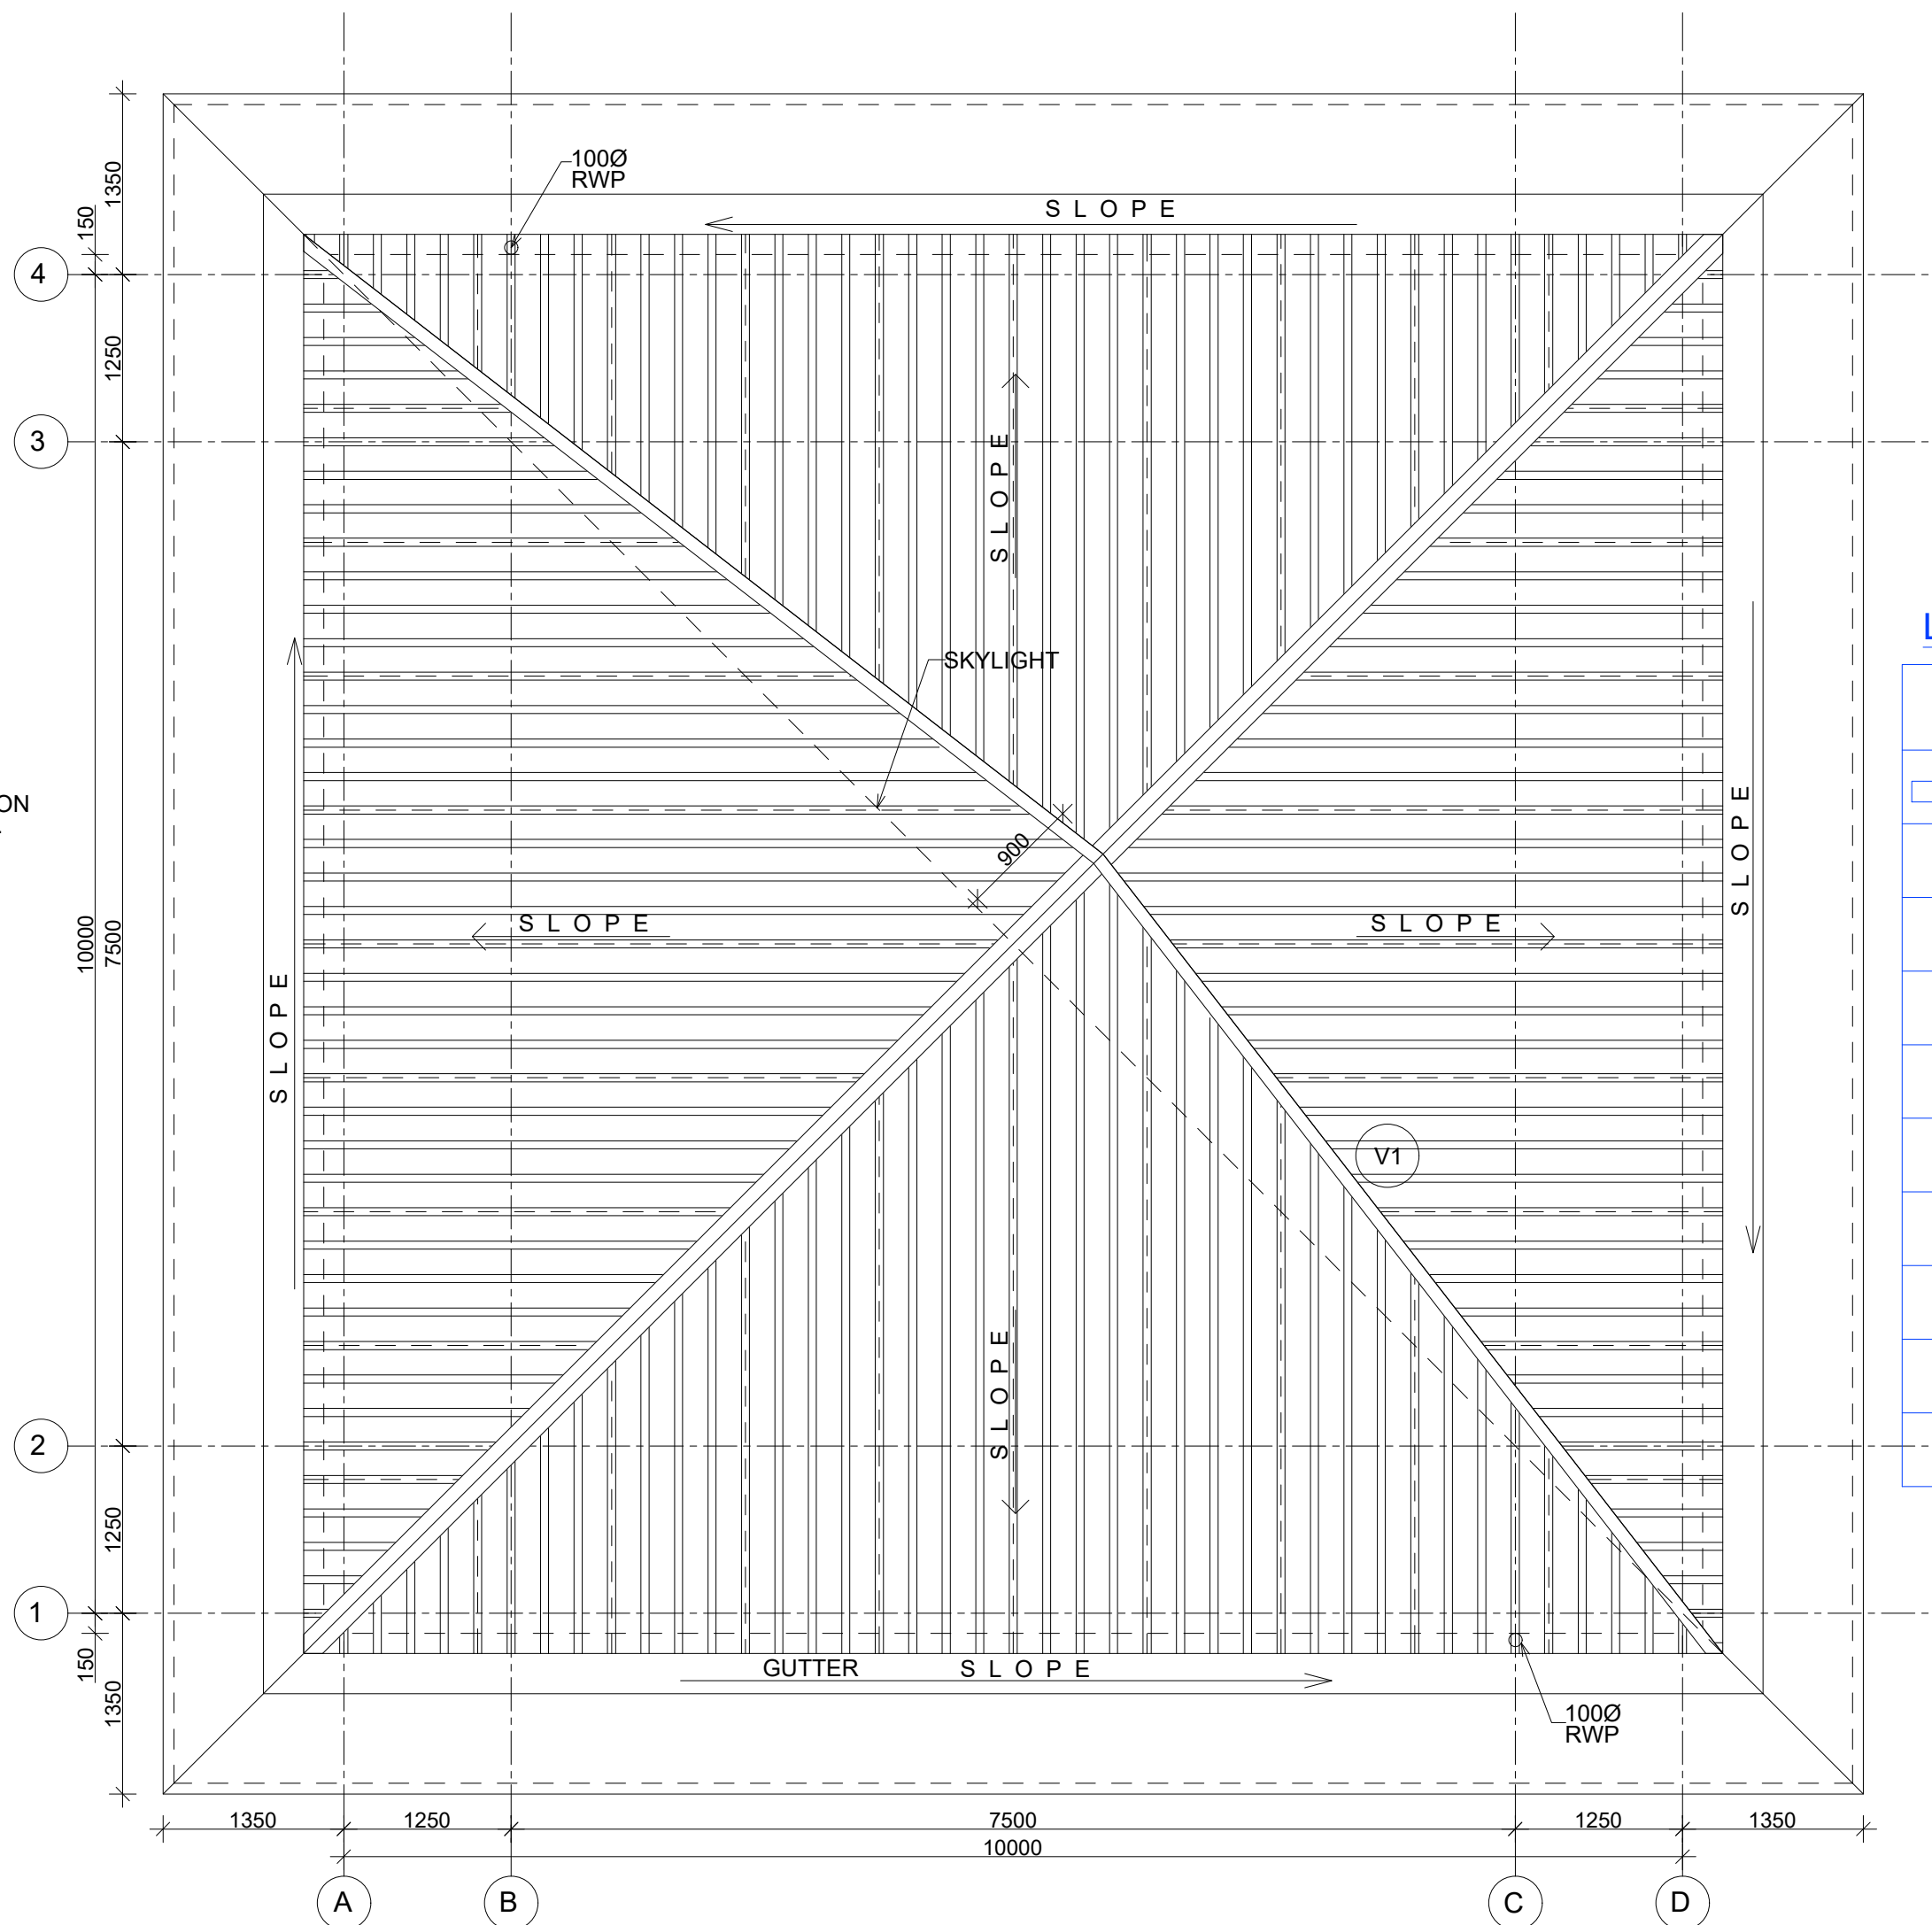

FLOOR PLAN AT LEVEL 00

LEGEND

	LED DOWN LIGHT
	LINEAR LIGHT FIXTURE
	RECESSED LIGHT FIXTURE
	6A SWITCH SOCKET OUTLET
	16A SWITCH SOCKET OUTLET
	20A SWITCH SOCKET OUTLET
	TELEPHONE OUTLET
	DATA OUTLET
	CEILING FAN
	DISTRIBUTION BOARD
	CONTROL SWITCH

this drawing is the property of m/s kanvinde rai & chowdhury and shall not be used or copied without their permission

notes :

all dimensions are in mm

the contractor must verify all the dimensions on site before commencement of work

do not scale this drawing

north point key plan



revisions

date no. description

29.10.25 mail TO IWD
date no. issue

TENDER DRAWING

kanvinde rai & chowdhury
architects & planners

14 f middle circle connaught place,
new delhi - 110 001 tel : 23312881 23313649


job title

IIT KANPUR

sheet title

VISITOR'S HOSTEL
CAFE
ELECTRICAL LAYOUT

job no.	560/ IITK/ VHCAFE	drg. no.
date	OCT 2025	
dealt	AA	ED-110
scale	1:50	

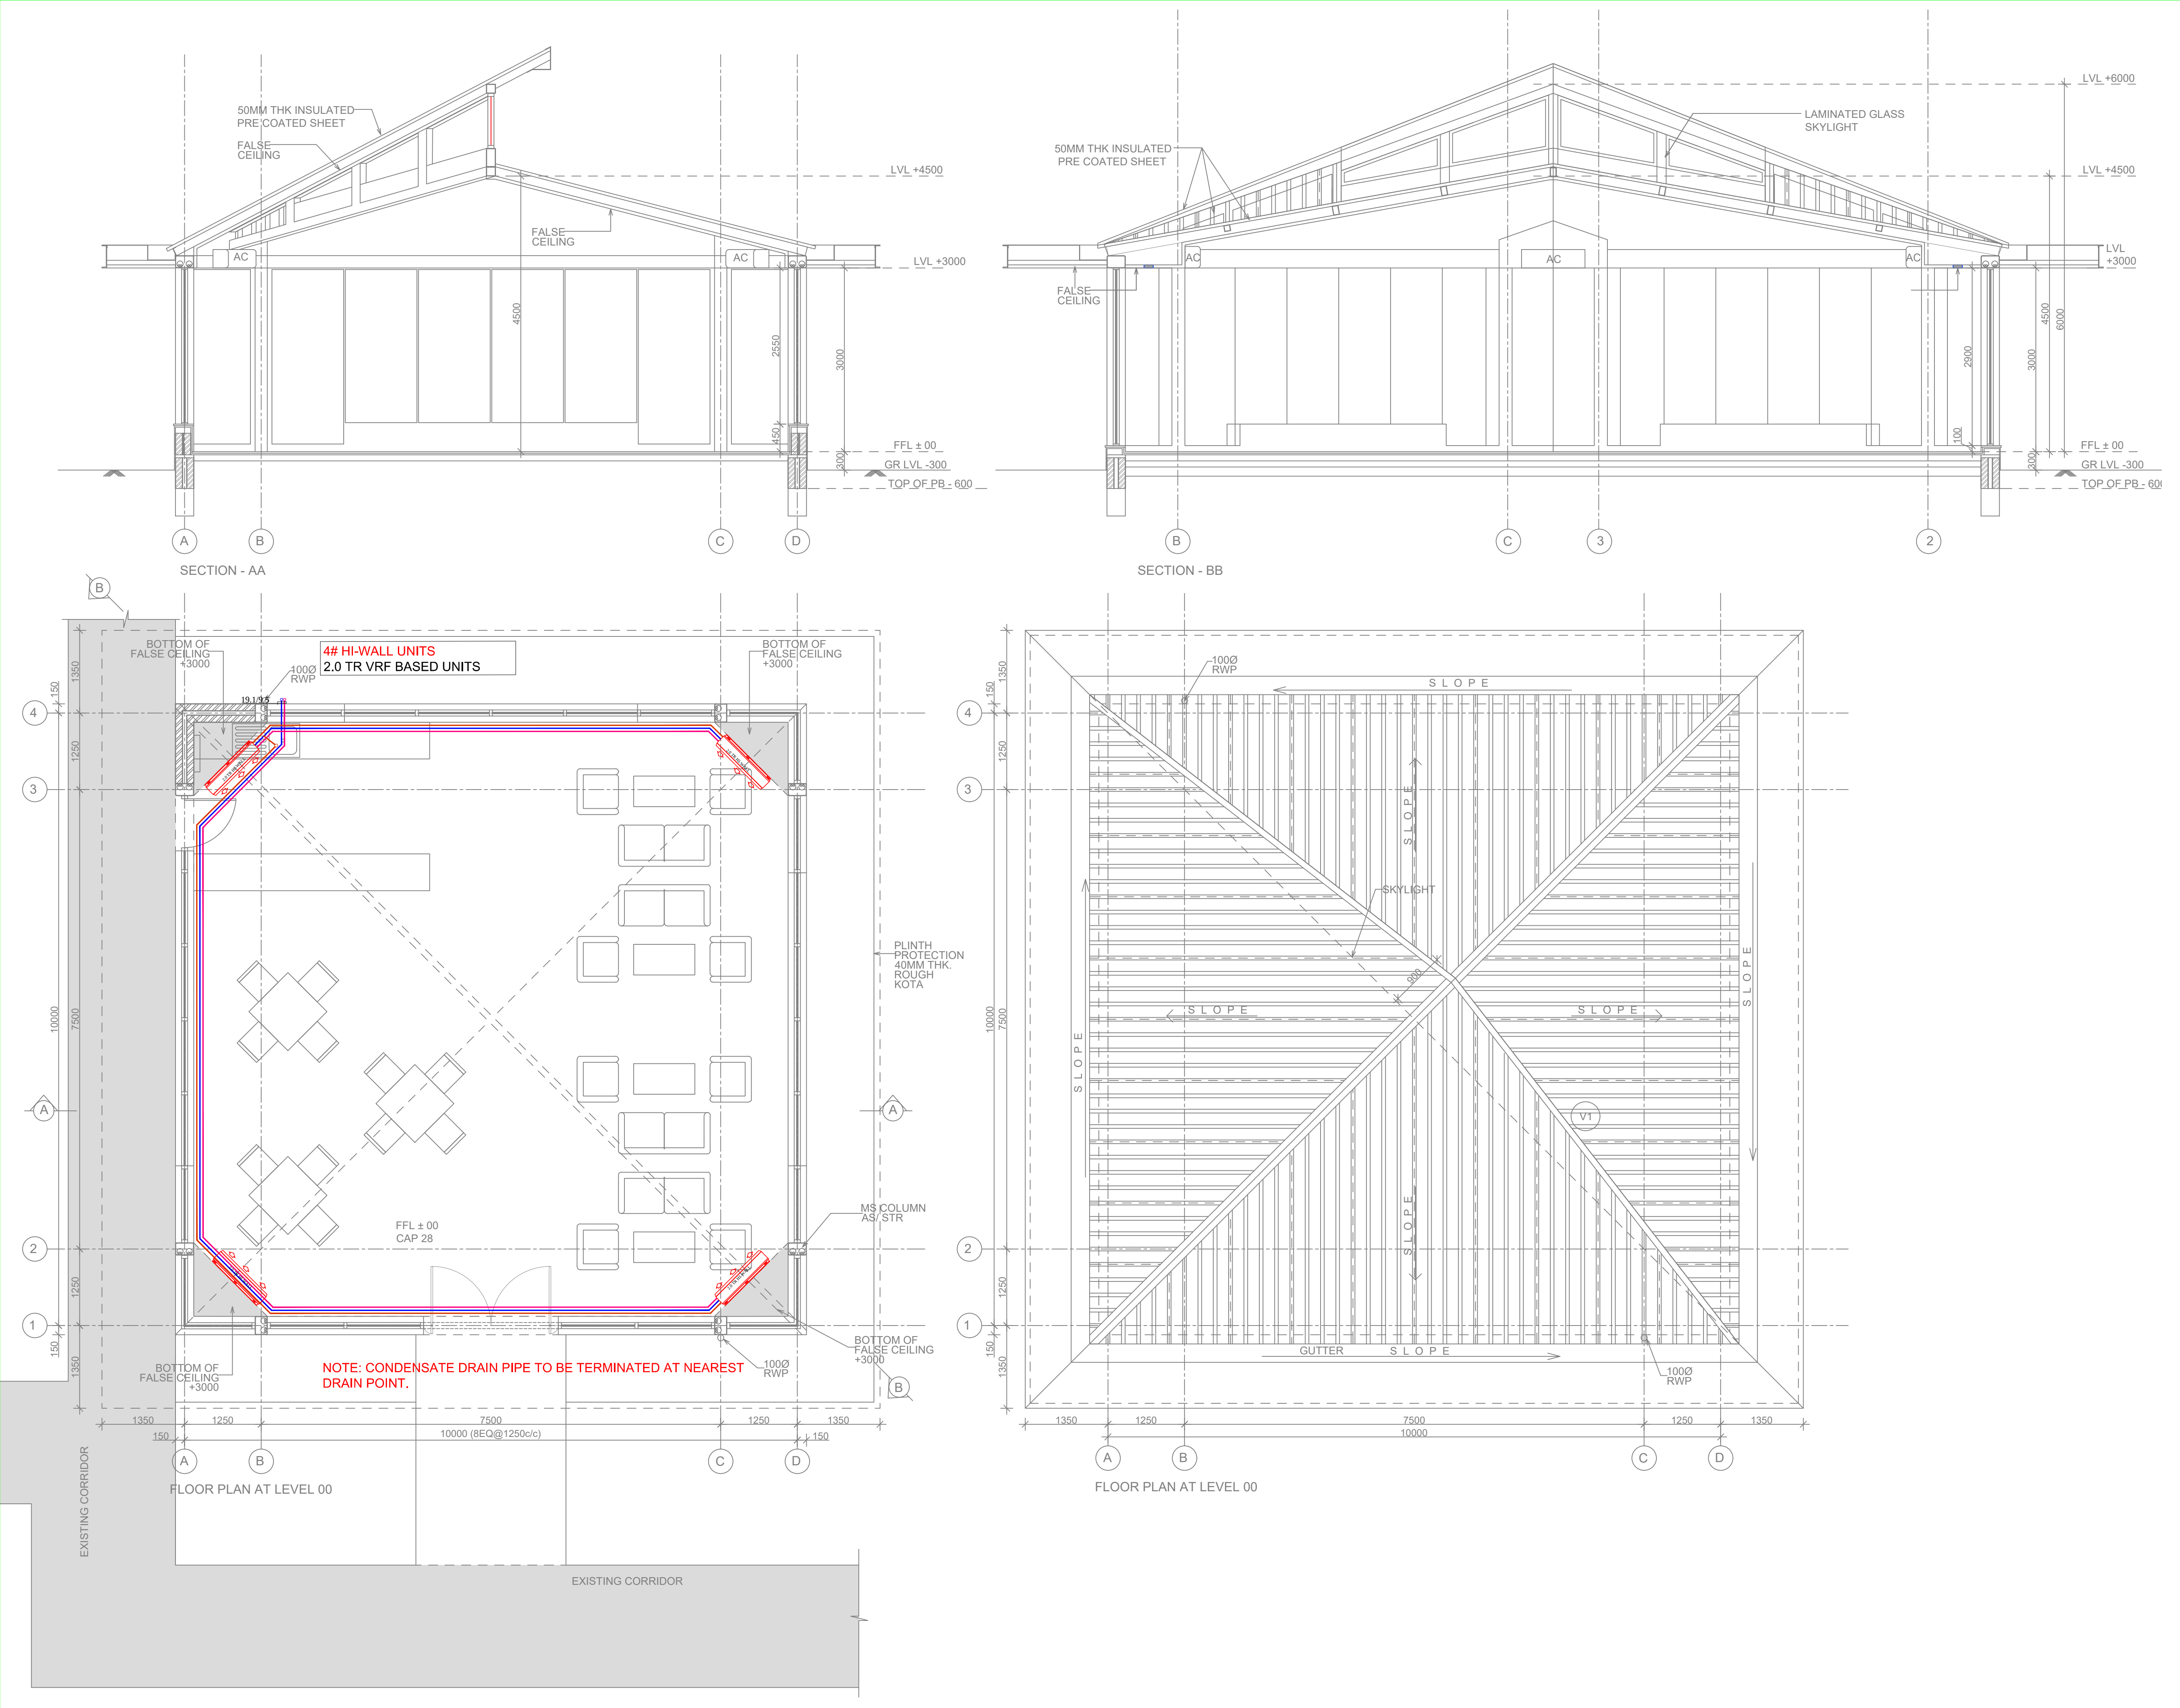

this drawing is the property of m/s kanvinde rai & chowdhury and shall not be used or copied without their permission

notes :

all dimensions are in mm

the contractor must verify all the dimensions on site before commencement of work

do not scale this drawing

north point key plan



revisions

date no. description

29.10.25 mail TO IWD
date no. issue

TENDER DRAWING

kanvinde rai & chowdhury
architects & planners

14 f middle circle connaught place,
new delhi - 110 001 tel : 23312881 23313649

job title

IIT KANPUR

sheet title

VISITOR'S HOSTEL
CAFE
HVAC LAYOUT

job no. 560/ IITK/ VHCAFE drg. no.
date OCT 2025
dealt AA
scale 1:50